


# 8115 - GREAT HOUSE PROJECT

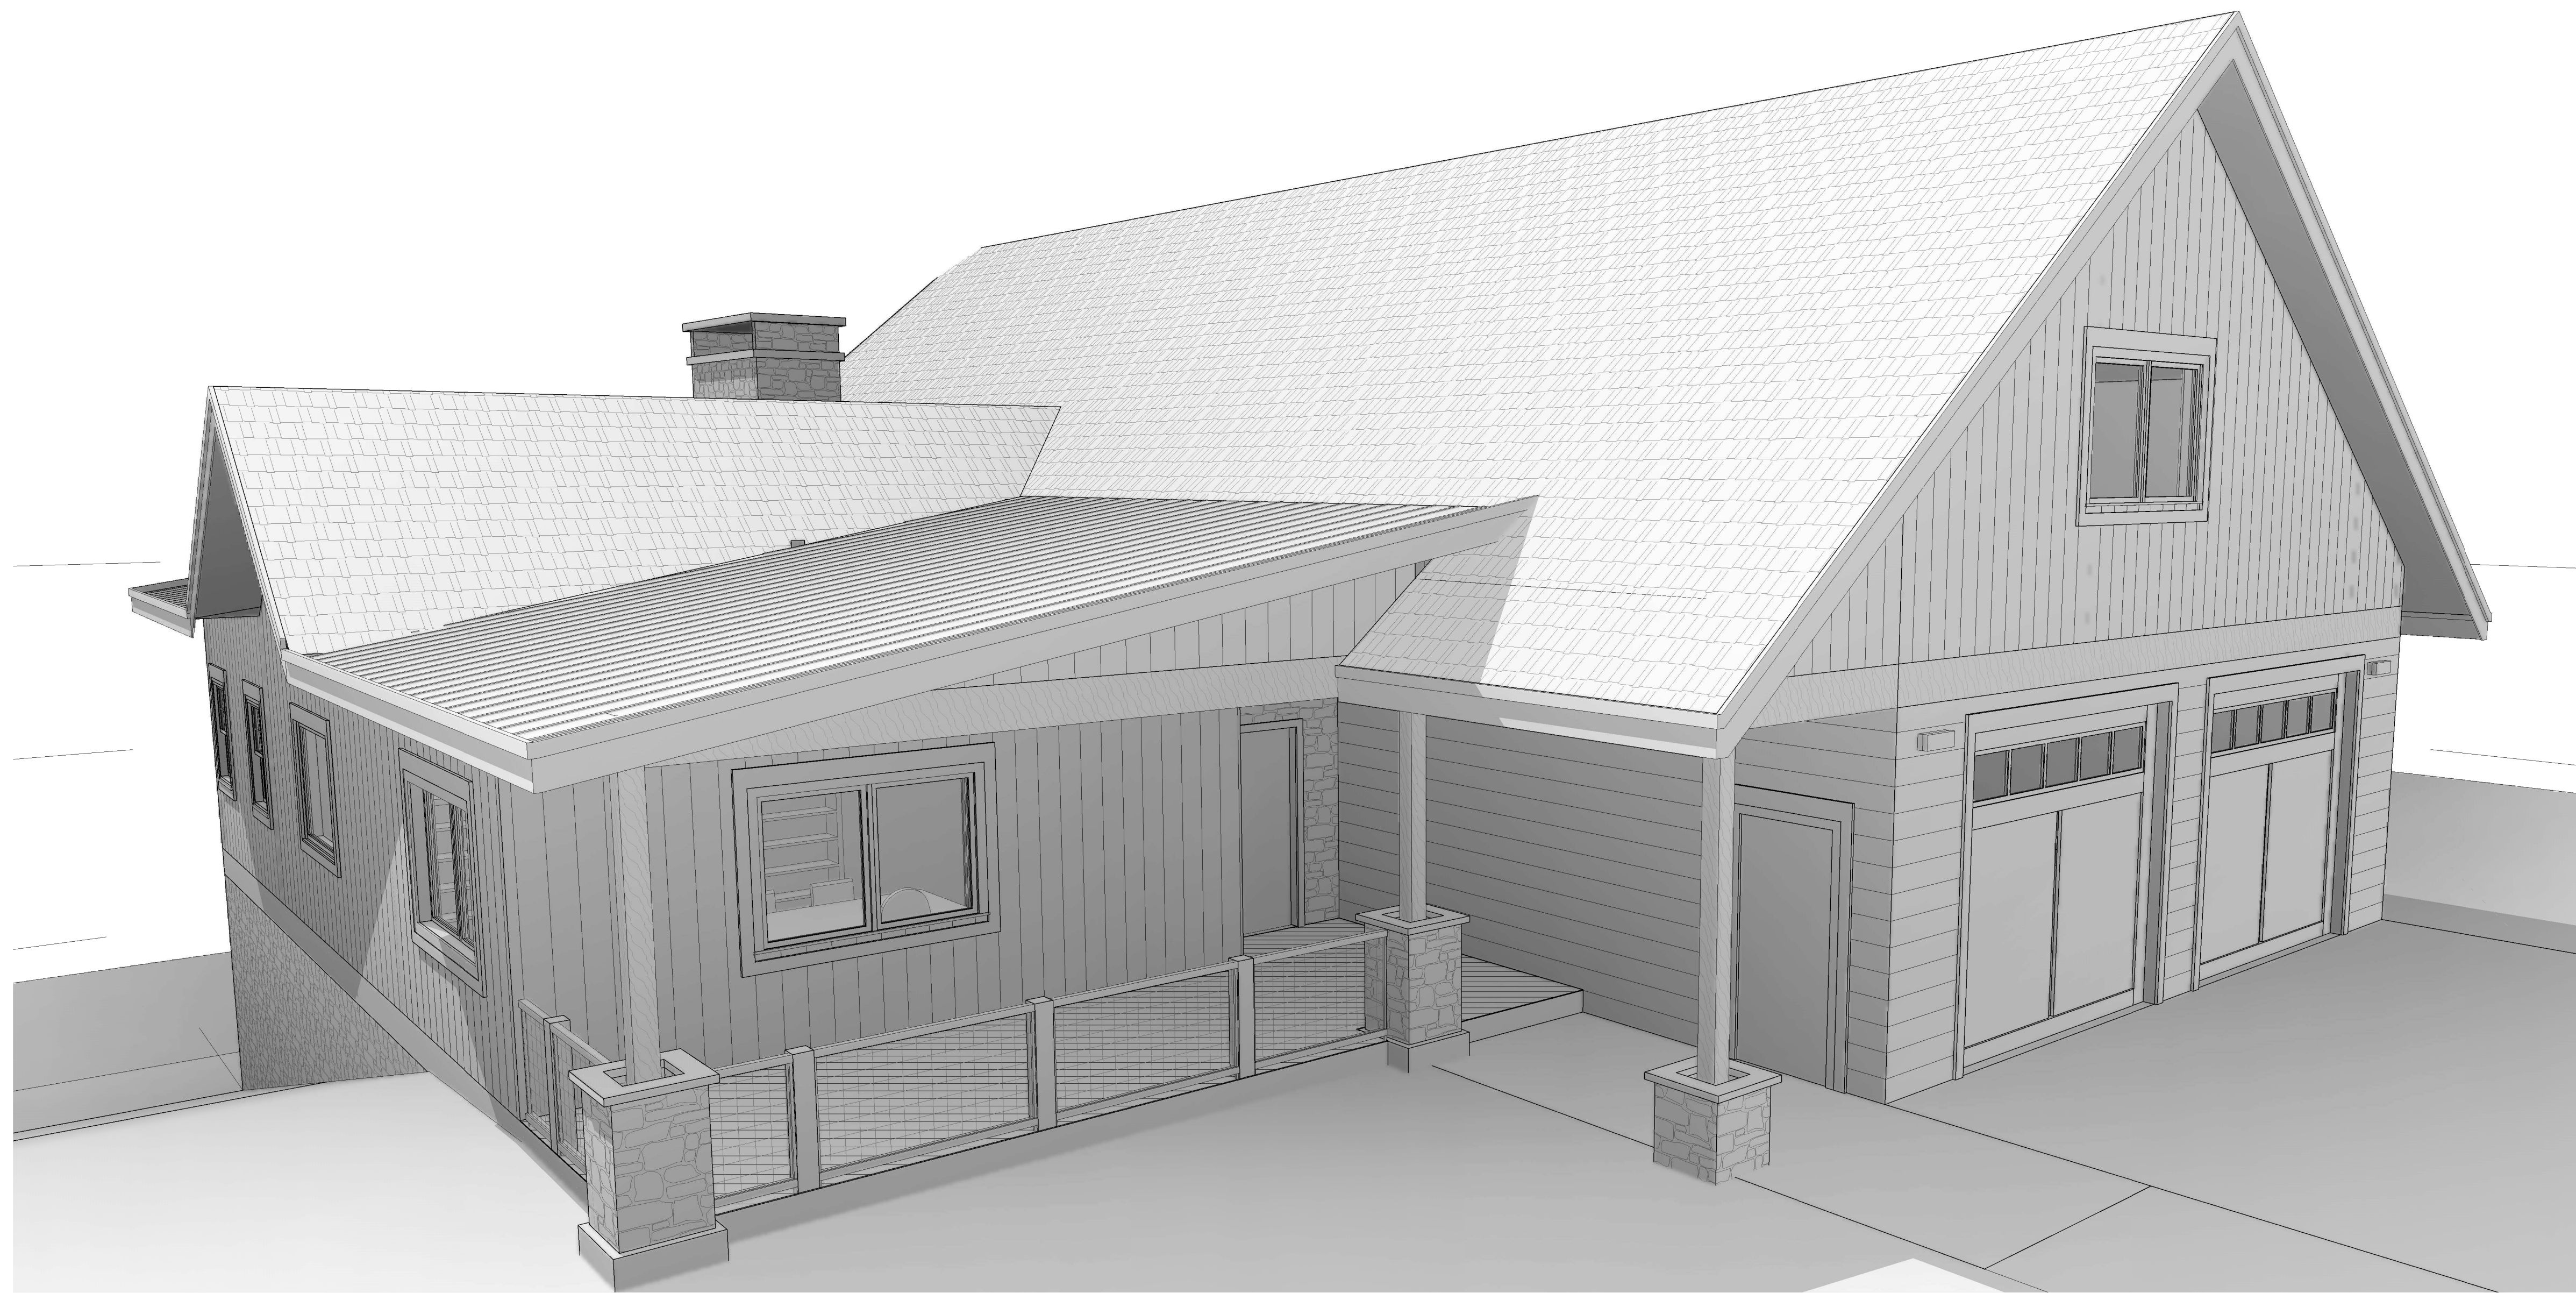

### INDEX OF DRAWINGS

A0.0	COVER
A0.1	EXTERIOR PERSPECTIVE VIEWS
A1.0	LOWER LEVEL PLAN
A1.1	MAIN LEVEL PLAN
A1.2	BONUS LEVEL PLAN
A1.3	ROOF PLAN
A2.0	NORTH AND EAST ELEVATIONS
A2.1	SOUTH AND WEST ELEVATION
A3.0	SECTIONS 1
A3.1	SECTIONS 2
A4.0	DOOR AND WINDOW DETAILS
A5.0	INTERIOR ELEVATIONS 1
A5.1	INTERIOR ELEVATIONS 2
A6.0	LOWER LEVEL - REFLECTED CEILING PLAN
A6.1	MAIN LEVEL - REFLECTED CEILING PLAN
A6.2	BONUS ROOM REFLECTED CEILING PLAN
A7.0	FINISH PLAN LOWER FLOOR
A7.1	FINISH PLAN MAIN FLOOR
A7.2	FINISH PLAN BONUS ROOM
A8.0	LOWER LEVEL-LIGHTING PLAN
A8.1	MAIN LEVEL-LIGHTING PLAN
A8.2	BONUS ROOM-LIGHTING PLAN

ARCHITECT'S SEAL :

DESIGN **efficiently**

CHECKED BY : Checker

DRAWN BY : Author

COMMENTS :

REVISION :

No.	Description	Date

8115-GREAT HOUSE PROJECT

TBD

COVER

Project Number **###**

Date **Issue Date**

Drawn By **Author**

Checked By **Checker**

**A0.0**

Scale





ARCHITECT'S SEAL :

DESIGN .efficiently

CHECKED BY : Checker

DRAWN BY : Author

COMMENTS :

\_\_\_\_\_

\_\_\_\_\_

\_\_\_\_\_

REVISION :

No.	Description	Date

8115-GREAT HOUSE  
PROJECT

TBD

EXTERIOR PERSPECTIVE VIEWS

Project Number ###.##

Date Issue Date

Drawn By Author

Checked By Checker

A0.1

Scale



ARCHITECT'S SEAL :

DESIGN *efficiently*

CHECKED BY : Checker

DRAWN BY : Author

COMMENTS :

REVISION :

No.	Description	Date

8115-GREAT HOUSE  
PROJECT

TBD

LOWER LEVEL PLAN

Project Number **###.##**

Date **Issue Date**

Drawn By **Author**

Checked By **Checker**

**A1.0**

Scale **1/4" = 1'-0"**



① LOWER LEVEL PLAN  
1/4" = 1'-0"

ARCHITECT'S SEAL :

DESIGN .efficiently

CHECKED BY : Checker

DRAWN BY : Author

COMMENTS :

REVISION :

No.	Description	Date

8115-GREAT HOUSE  
PROJECT

TBD

MAIN LEVEL PLAN

Project Number ##.##


Date Issue Date

Drawn By Author

Checked By Checker

A1.1

Scale 1/4" = 1'-0"

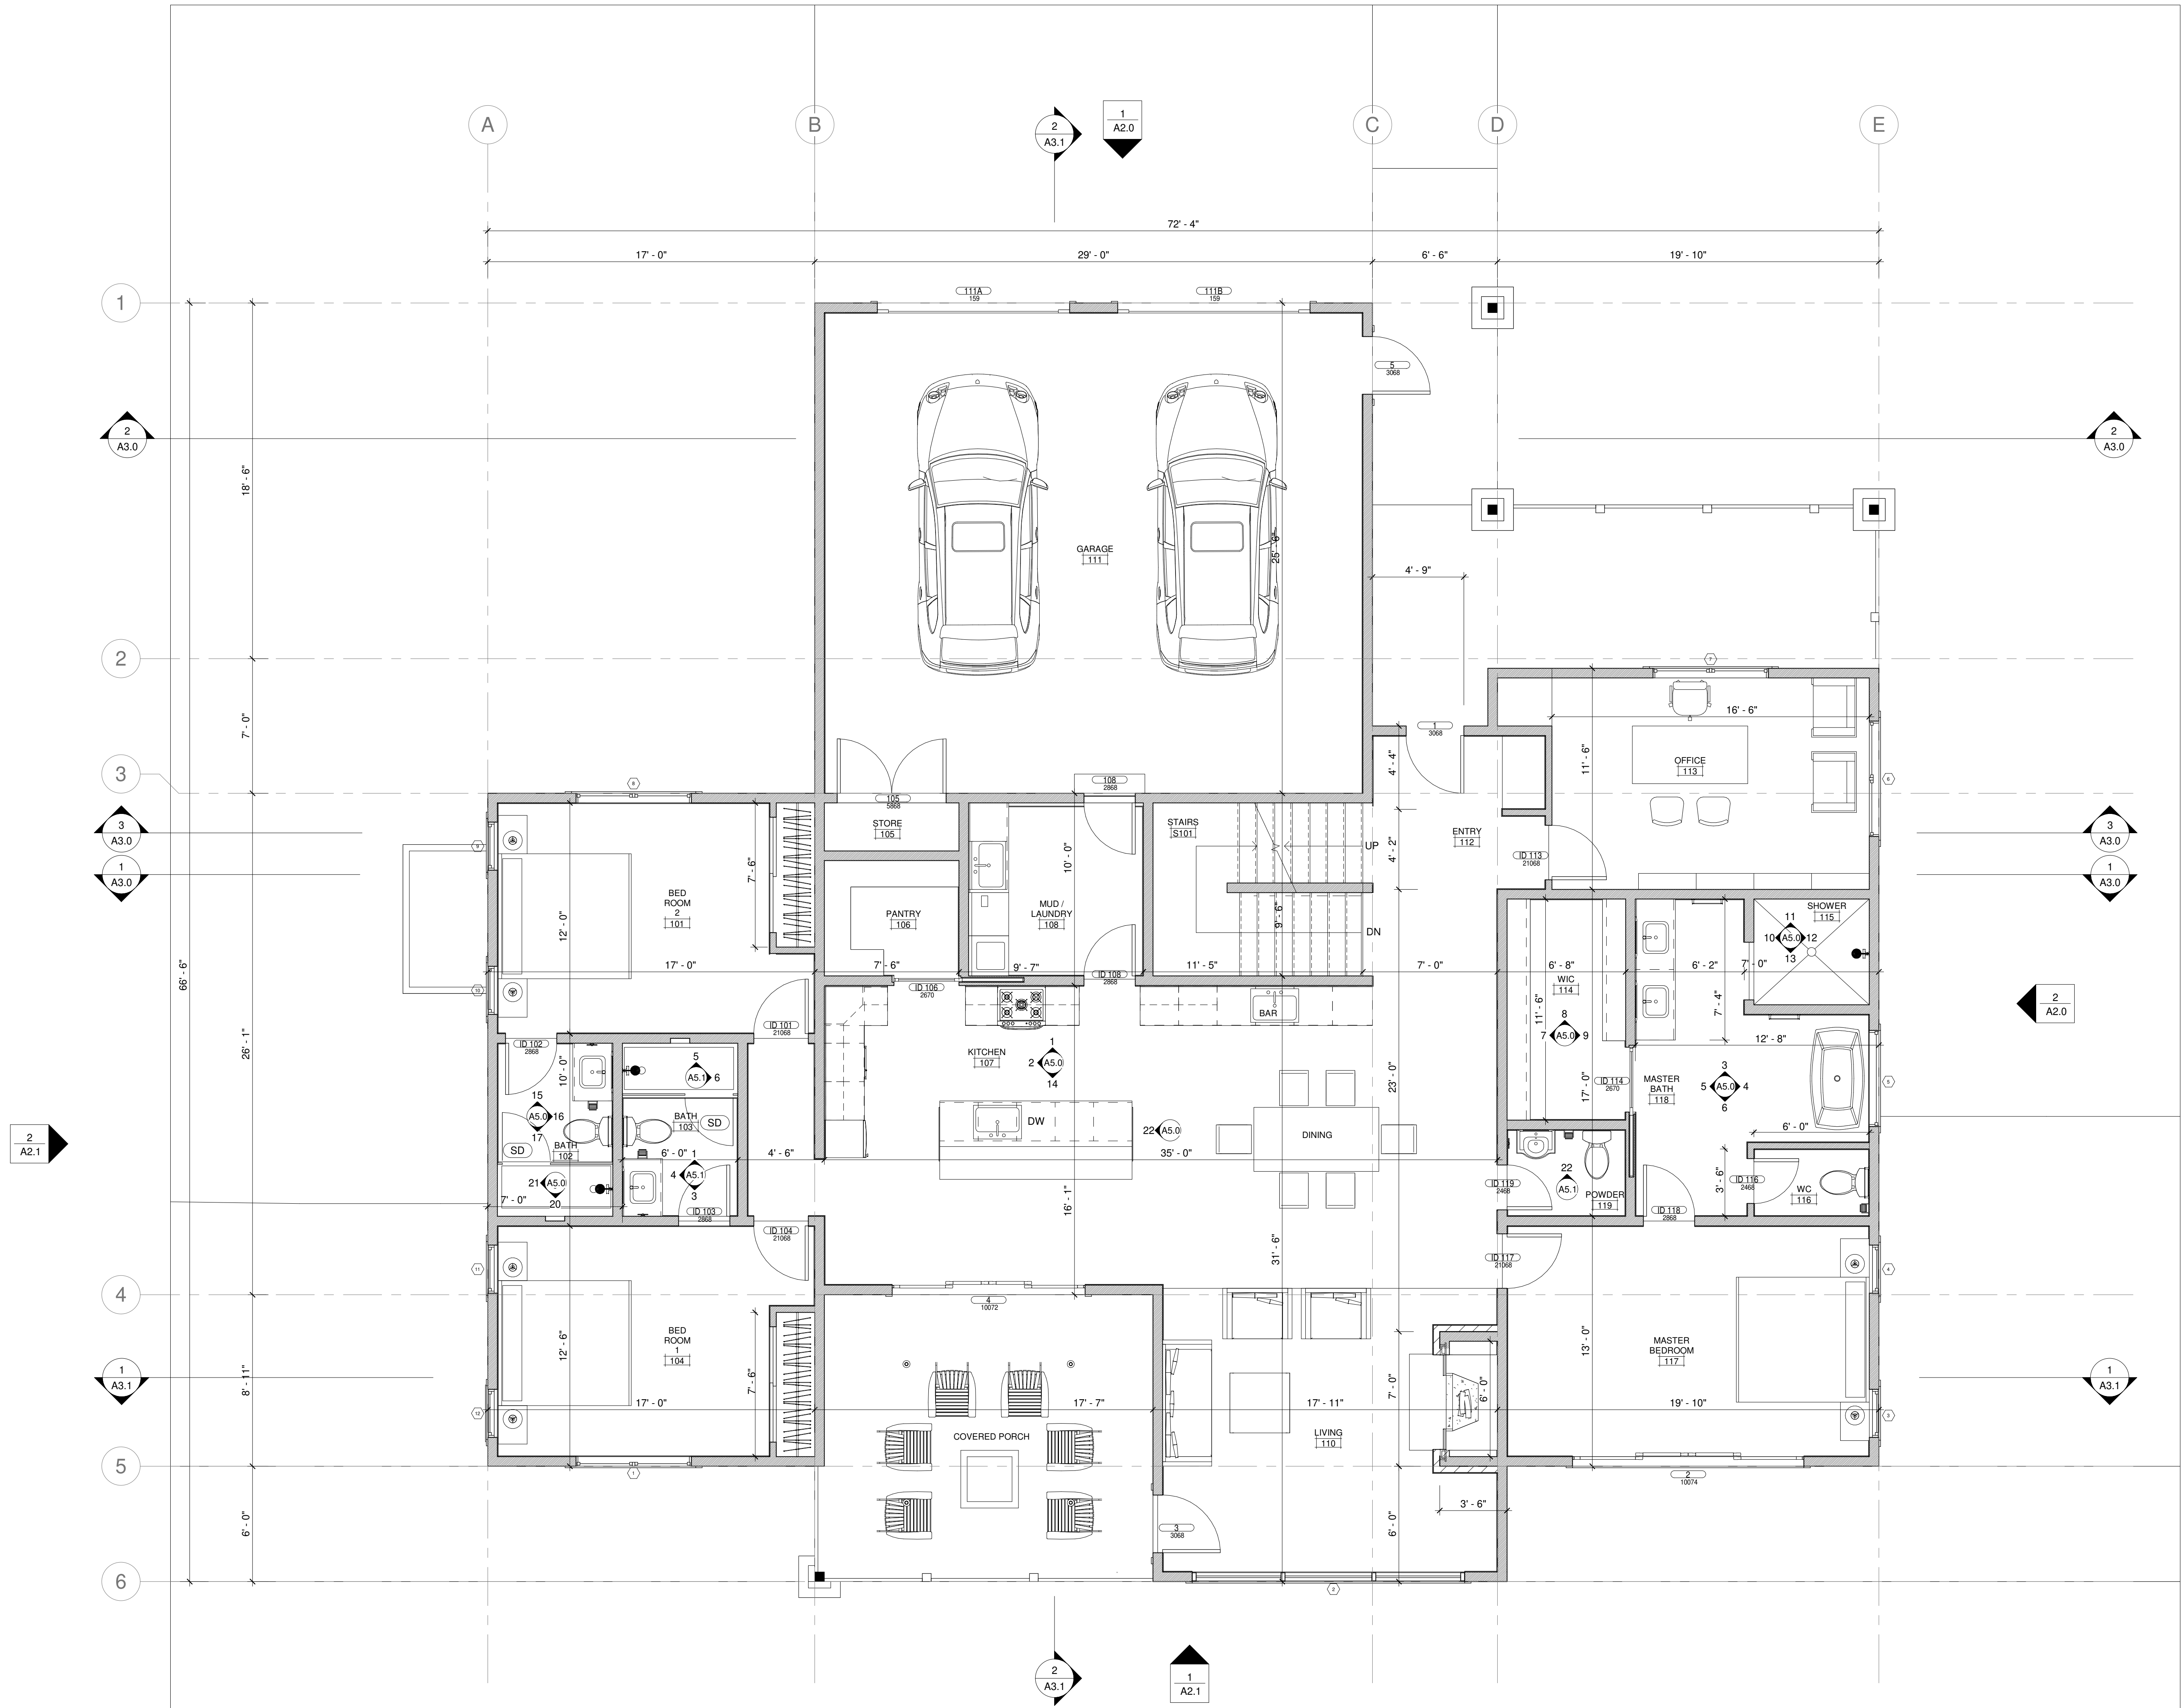

1 MAIN LEVEL PLAN  
1/4" = 1'-0"

ARCHITECT'S SEAL :

DESIGN **.efficiently**

CHECKED BY : Checker

DRAWN BY : Author

COMMENTS :

REVISION :

No.	Description	Date

8115-GREAT HOUSE  
PROJECT


TBD

BONUS LEVEL PLAN

Project Number	###
Date	Issue Date
Drawn By	Author
Checked By	Checker


**A1.2**

Scale 1/4" = 1'-0"

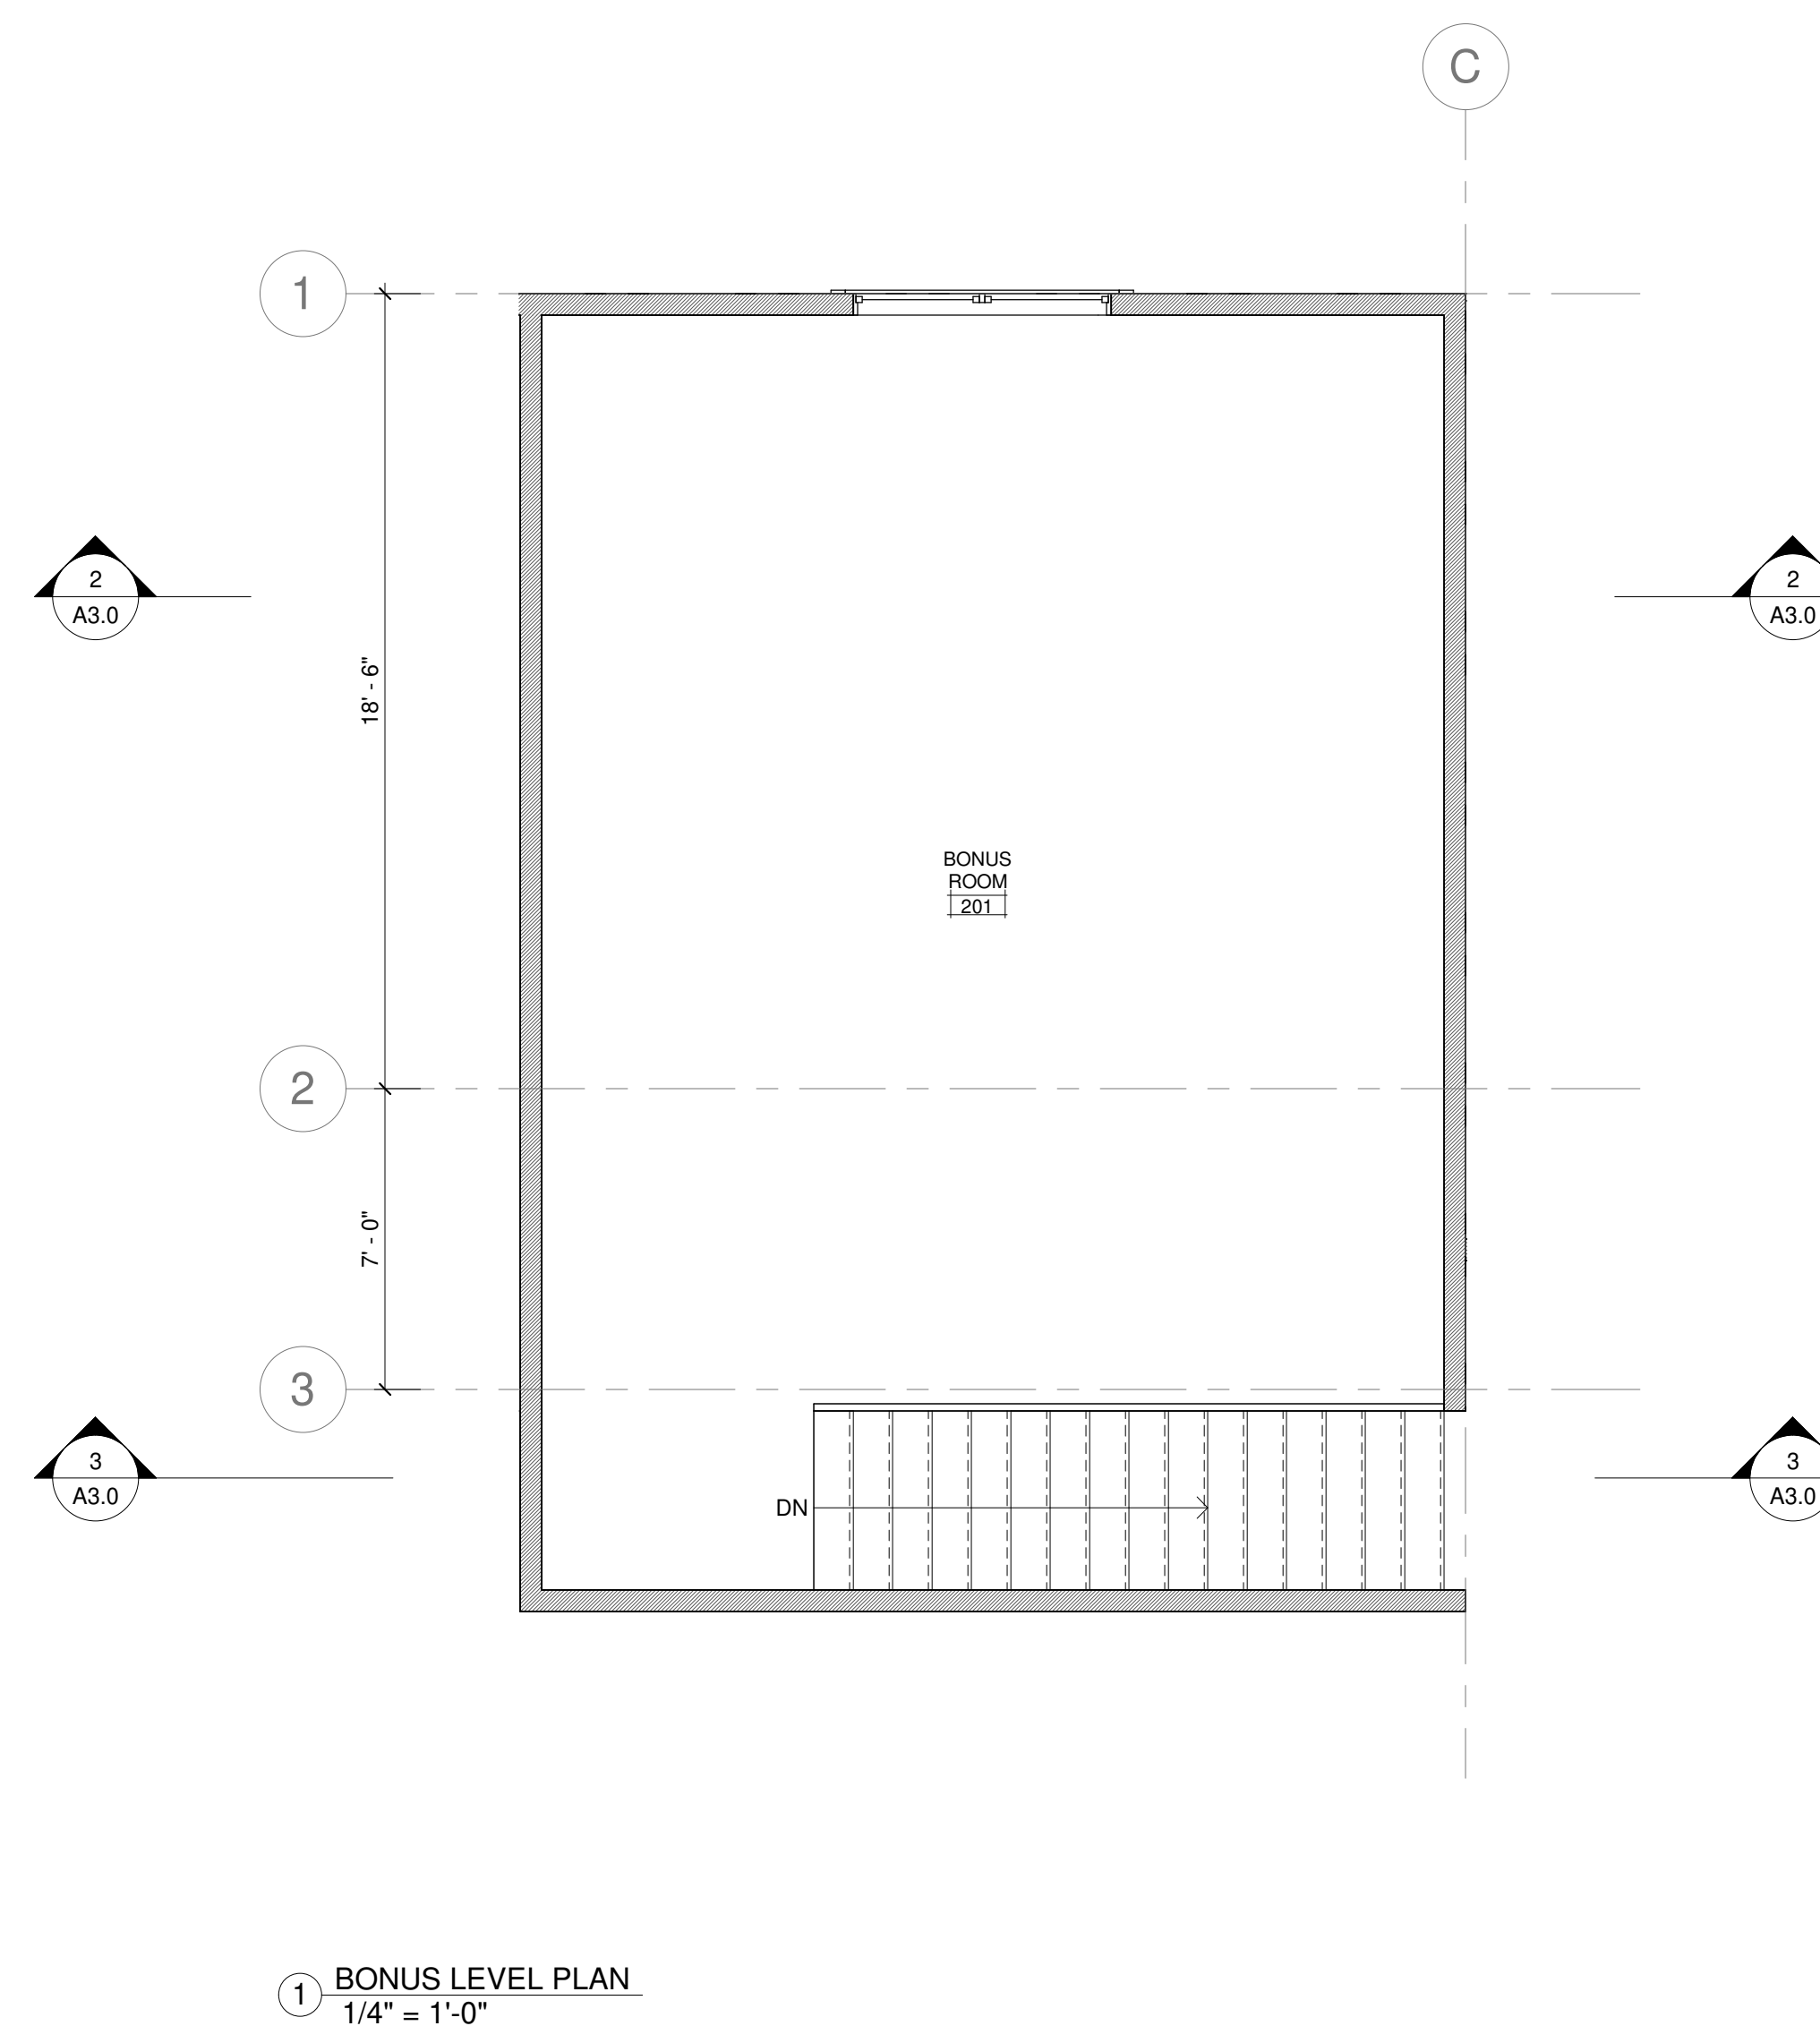

ROOF FINISH LEGEND	
R1	ASPHALT SHINGLES
R2	16" ON CENTRE STANDING SEAM STEEL ROOF

ARCHITECT'S SEAL :

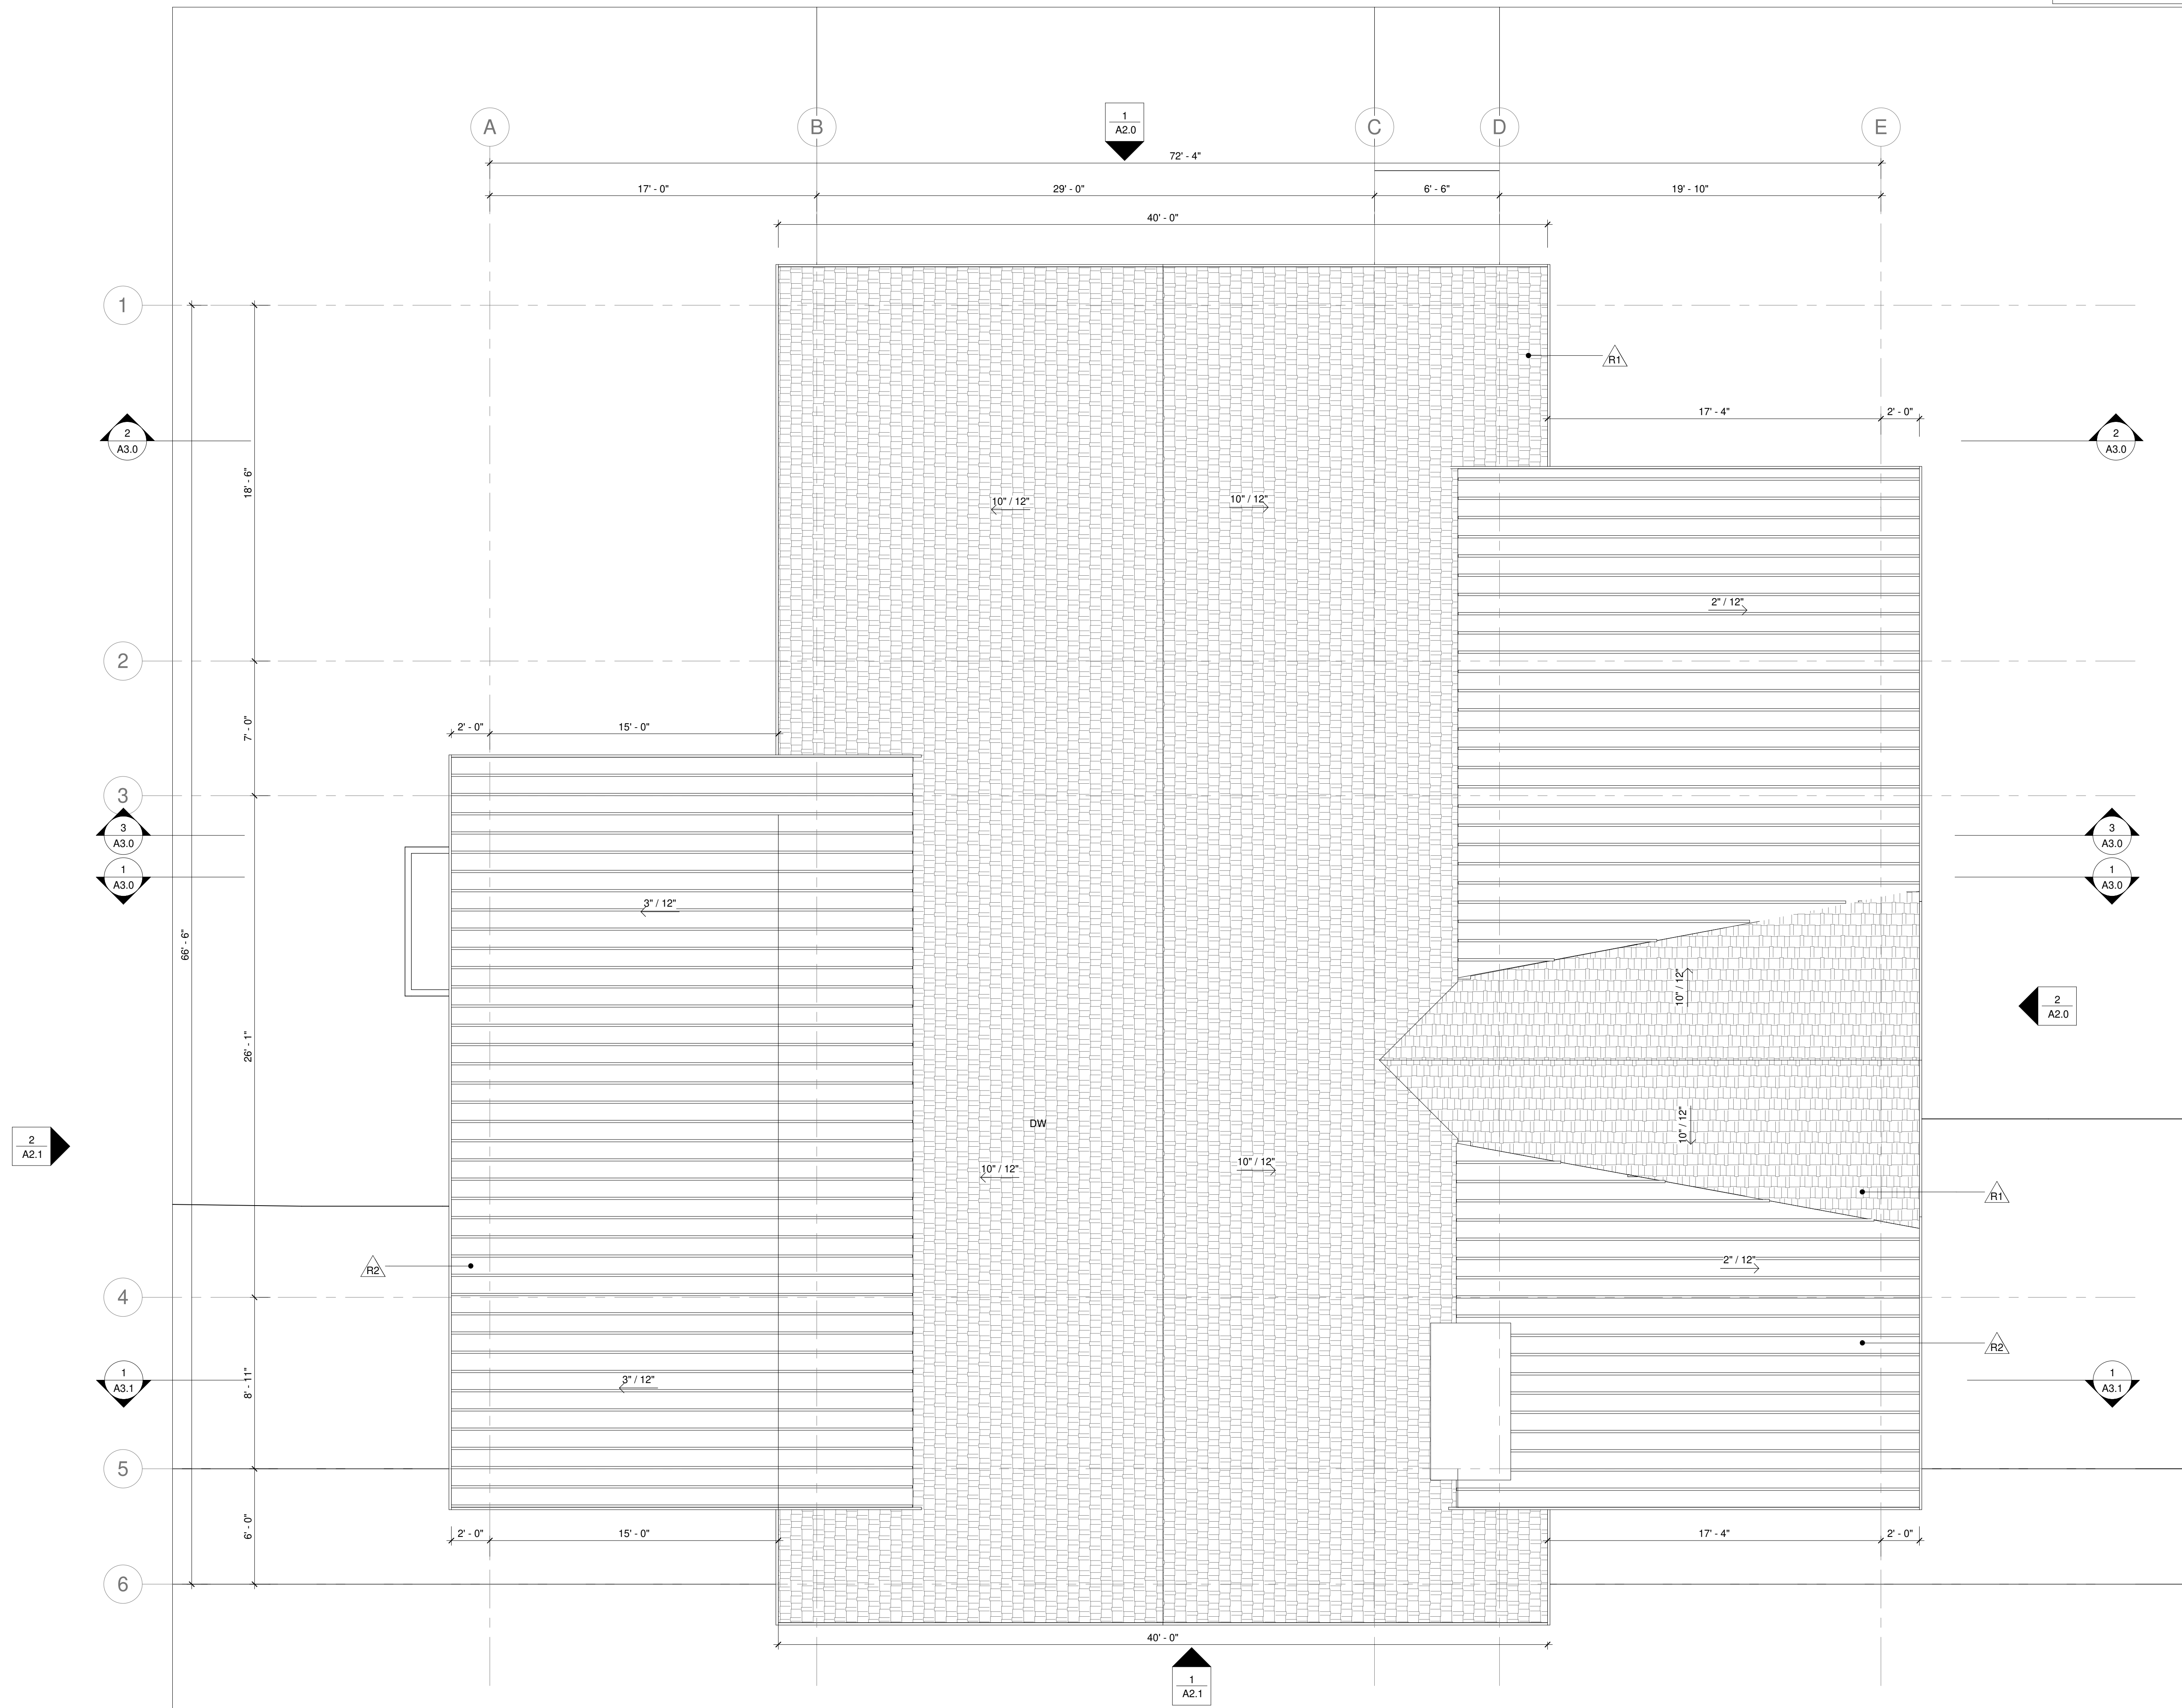

1 ROOF PLAN  
1/4" = 1'-0"

CHECKED BY : Checker  
 DRAWN BY : Author  
 COMMENTS :

REVISION :

No.	Description	Date

8115-GREAT HOUSE  
PROJECT


TBD

ROOF PLAN

Project Number	###.##
Date	Issue Date
Drawn By	Author
Checked By	Checker

**A1.3**

Scale	As indicated
-------	--------------

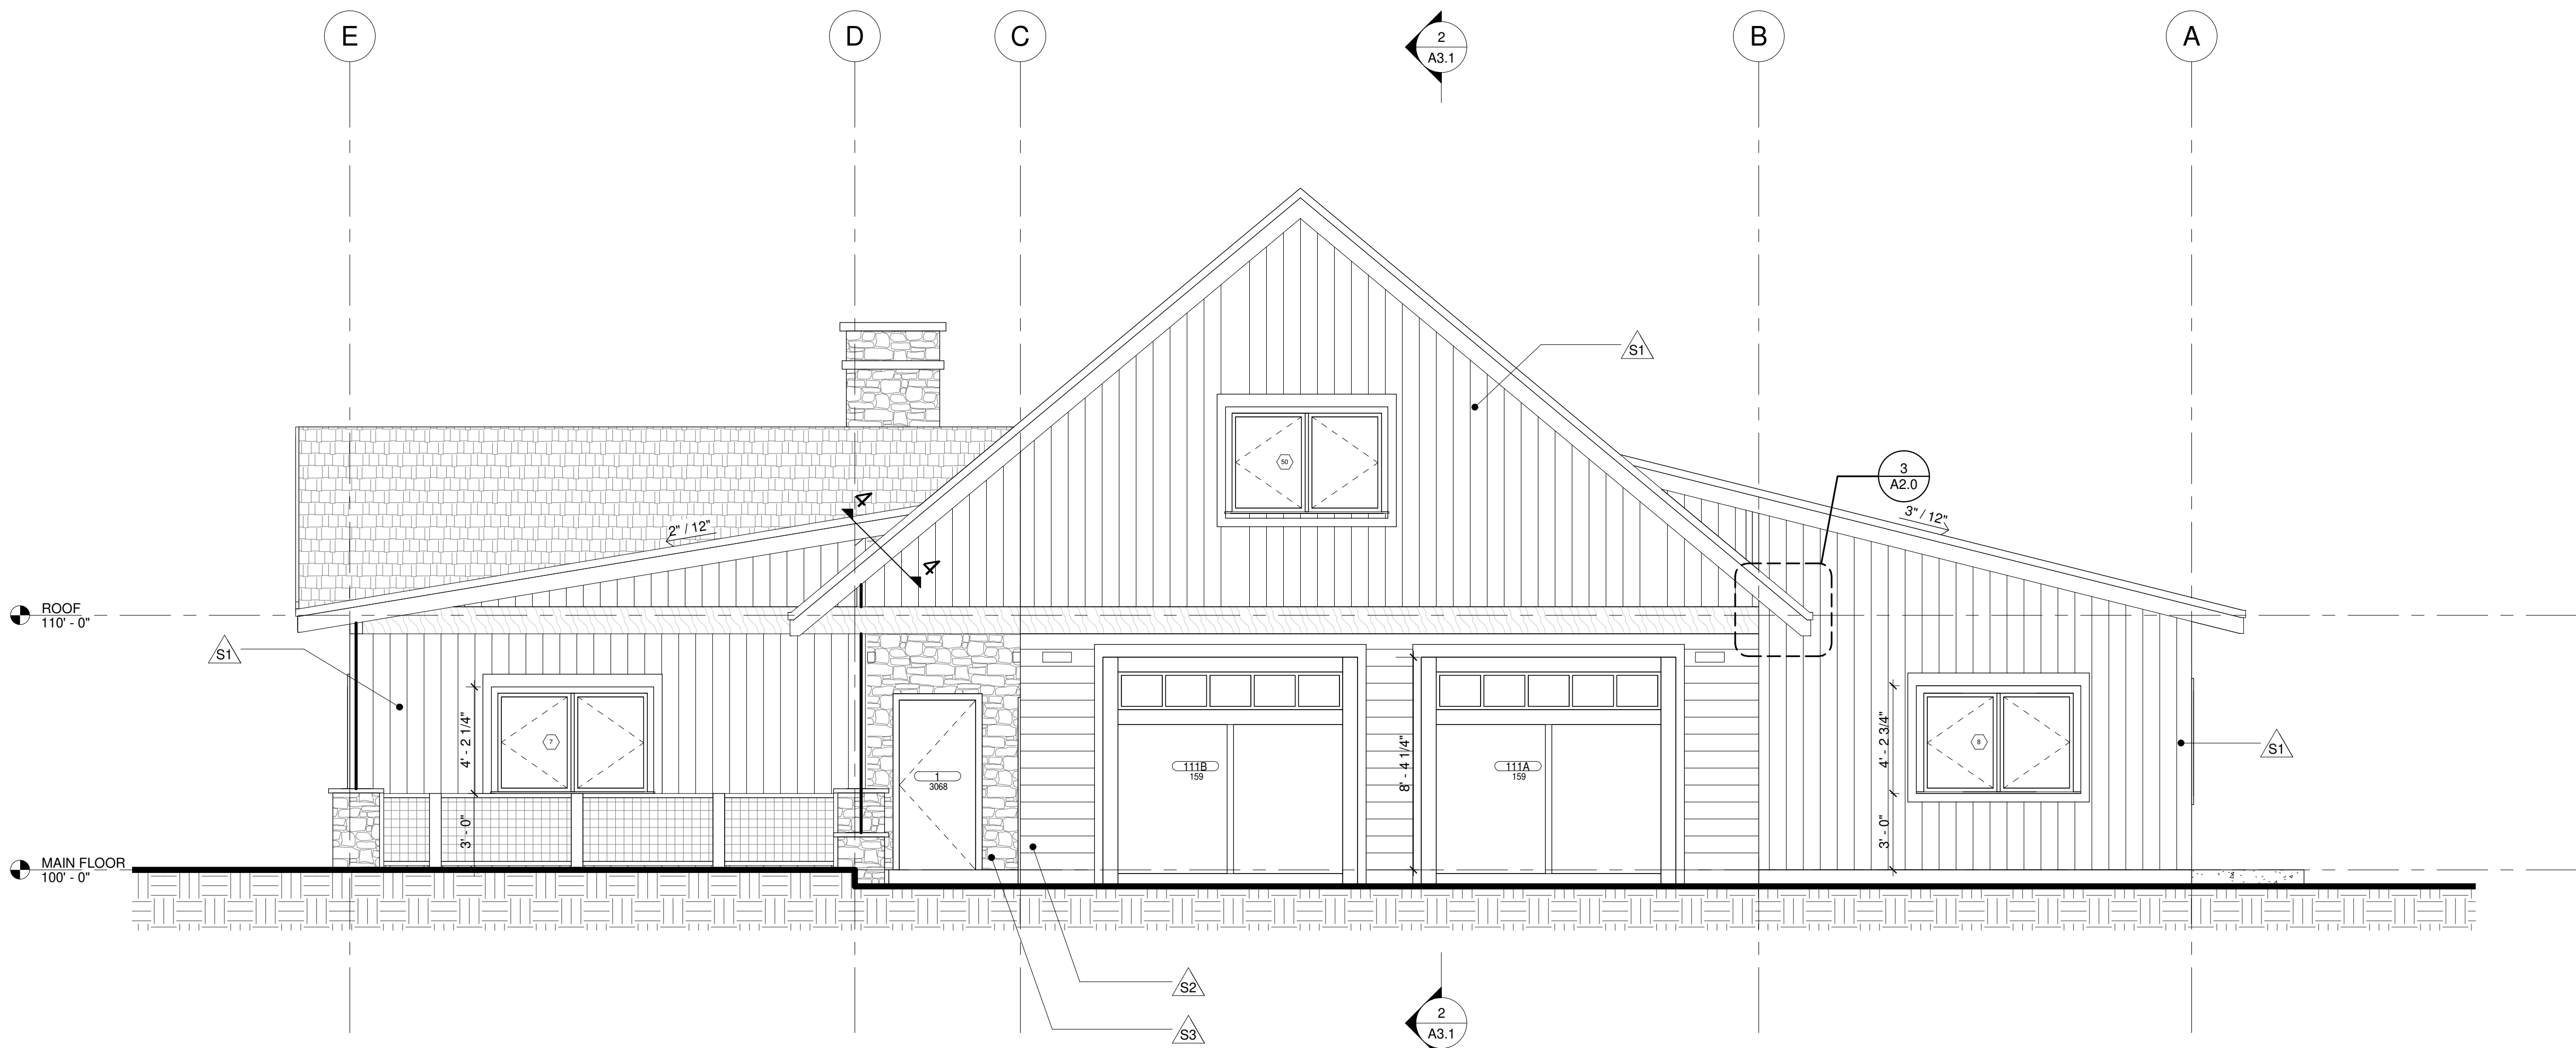


1 NORTH ELEVATION  
1/4" = 1'-0"




2 EAST ELEVATION  
1/4" = 1'-0"

FINISH LEGEND	
S1	VERTICAL SIDING
S2	HORIZONTAL SIDING
S3	MASONRY

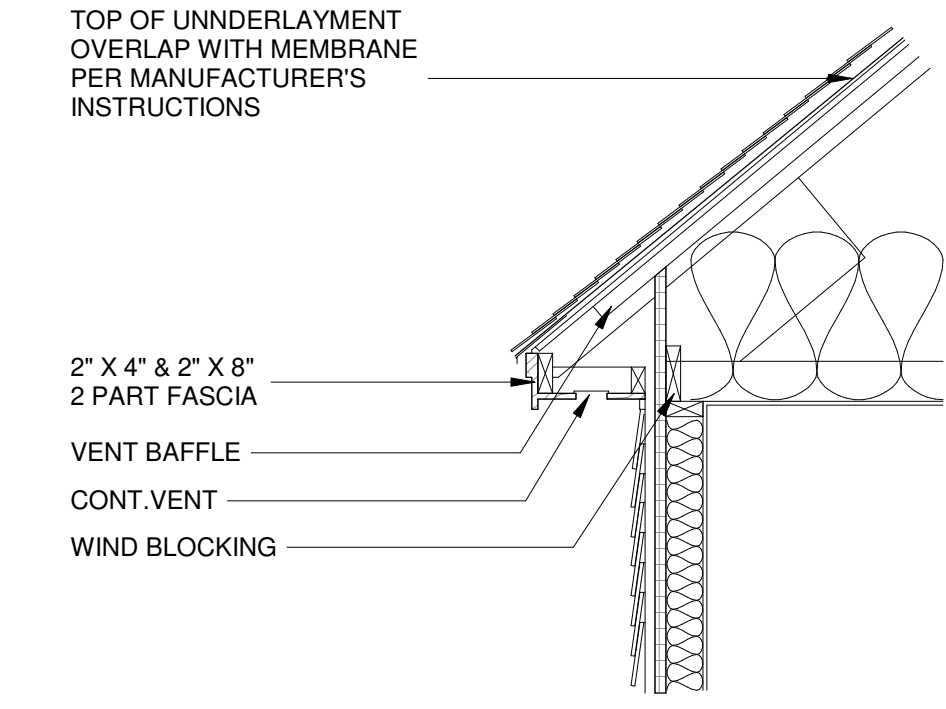

3 ROOF DETAIL-1  
1/2" = 1'-0"

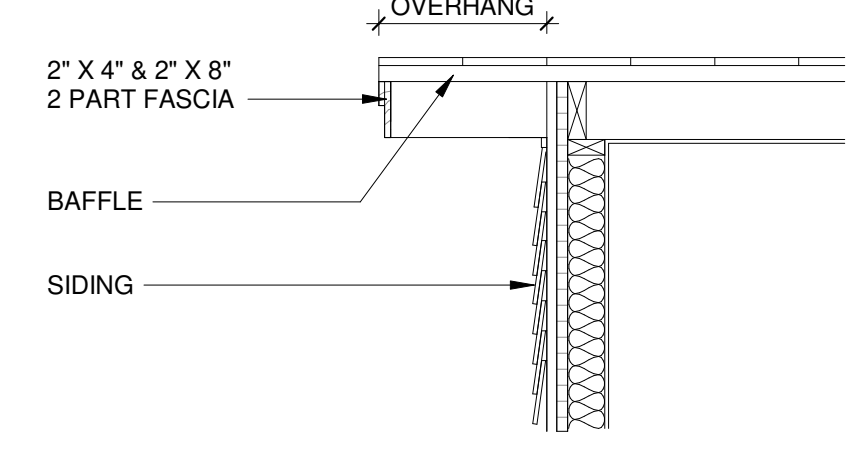

4 ROOF DETAIL-2  
1/2" = 1'-0"

ARCHITECT'S SEAL :

**DESIGN .efficiently**

CHECKED BY : Checker  
DRAWN BY : Author  
COMMENTS :

REVISION :

No.	Description	Date

**8115-GREAT HOUSE PROJECT**

TBD

NORTH AND EAST ELEVATIONS

Project Number	###
Date	Issue Date
Drawn By	Author
Checked By	Checker

**A2.0**

Scale	As indicated
-------	--------------



**FINISH LEGEND**

S1	VERTICAL SIDING
S2	HORIZONTAL SIDING
S3	MASONRY

ARCHITECT'S SEAL :




CHECKED BY : Checker

DRAWN BY : Author

COMMENTS :

REVISION :

No.	Description	Date

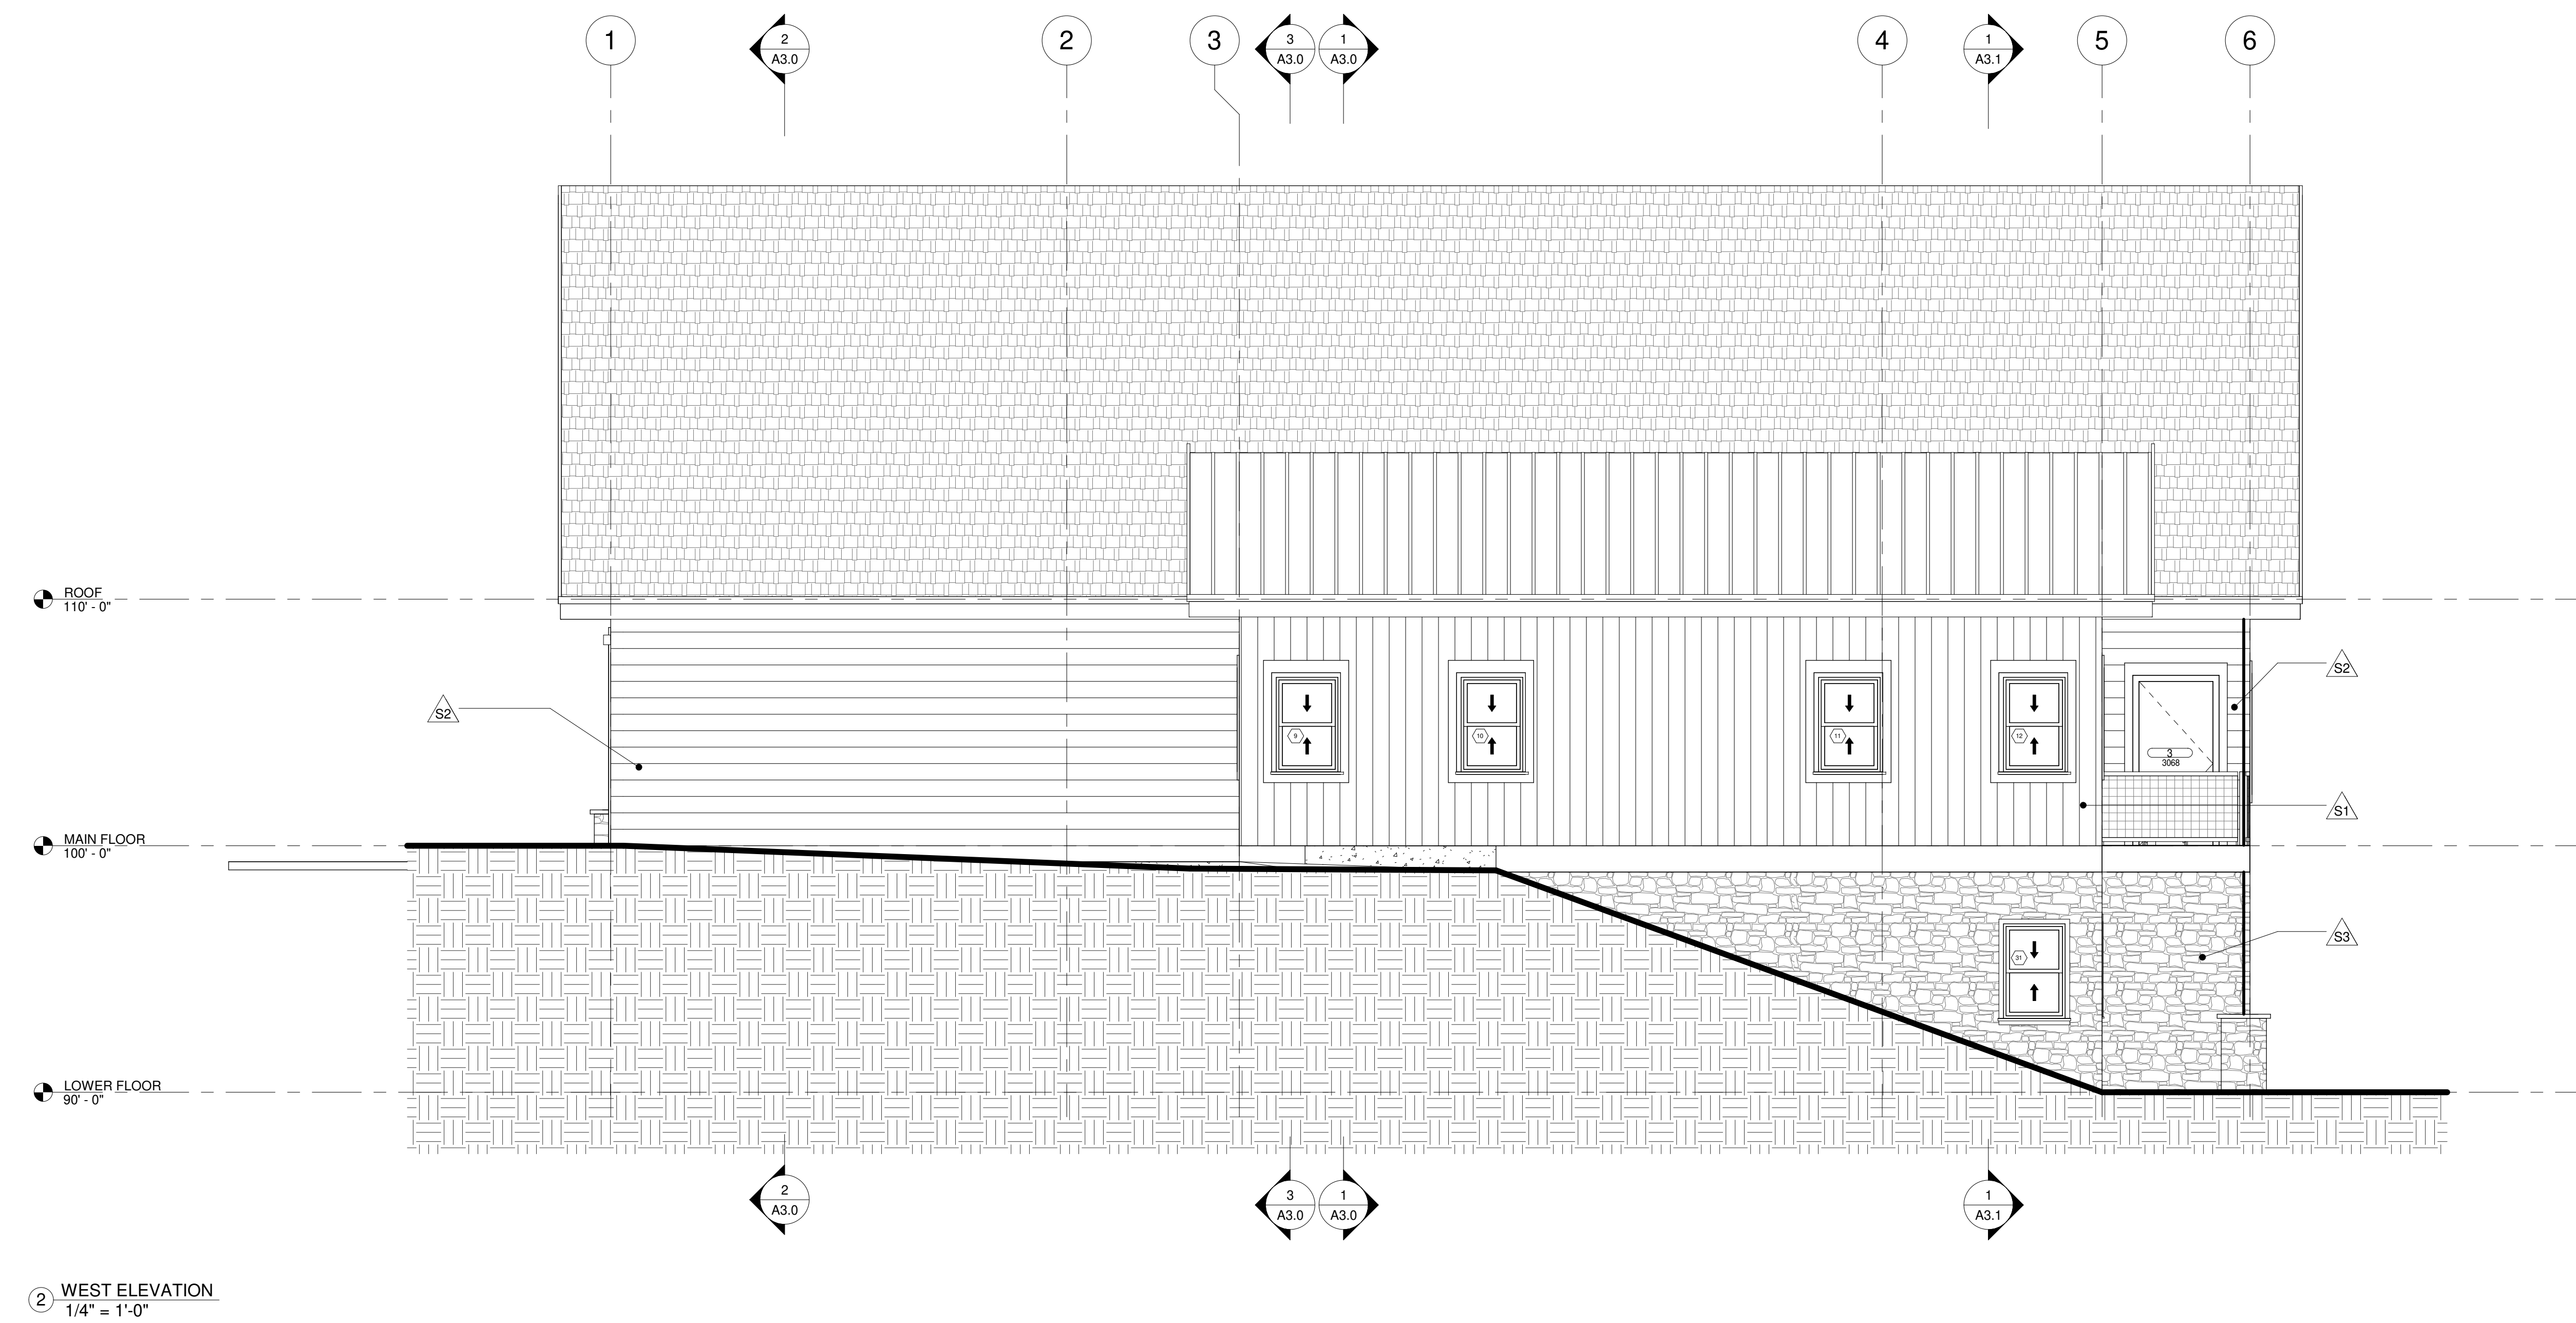

8115-GREAT HOUSE  
PROJECT

TBD

SOUTH AND WEST ELEVATION

Project Number	###.##
Date	Issue Date
Drawn By	Author
Checked By	Checker

**A2.1**

Scale	As indicated
-------	--------------



ARCHITECT'S SEAL :

DESIGN efficiently

CHECKED BY : Checker

DRAWN BY : Author

COMMENTS :

REVISION :

No.	Description	Date

8115-GREAT HOUSE  
PROJECT


TBD

SECTIONS 1


Project Number	###.##
Date	Issue Date
Drawn By	Author
Checked By	Checker

A3.0


Scale 1/4" = 1'-0"

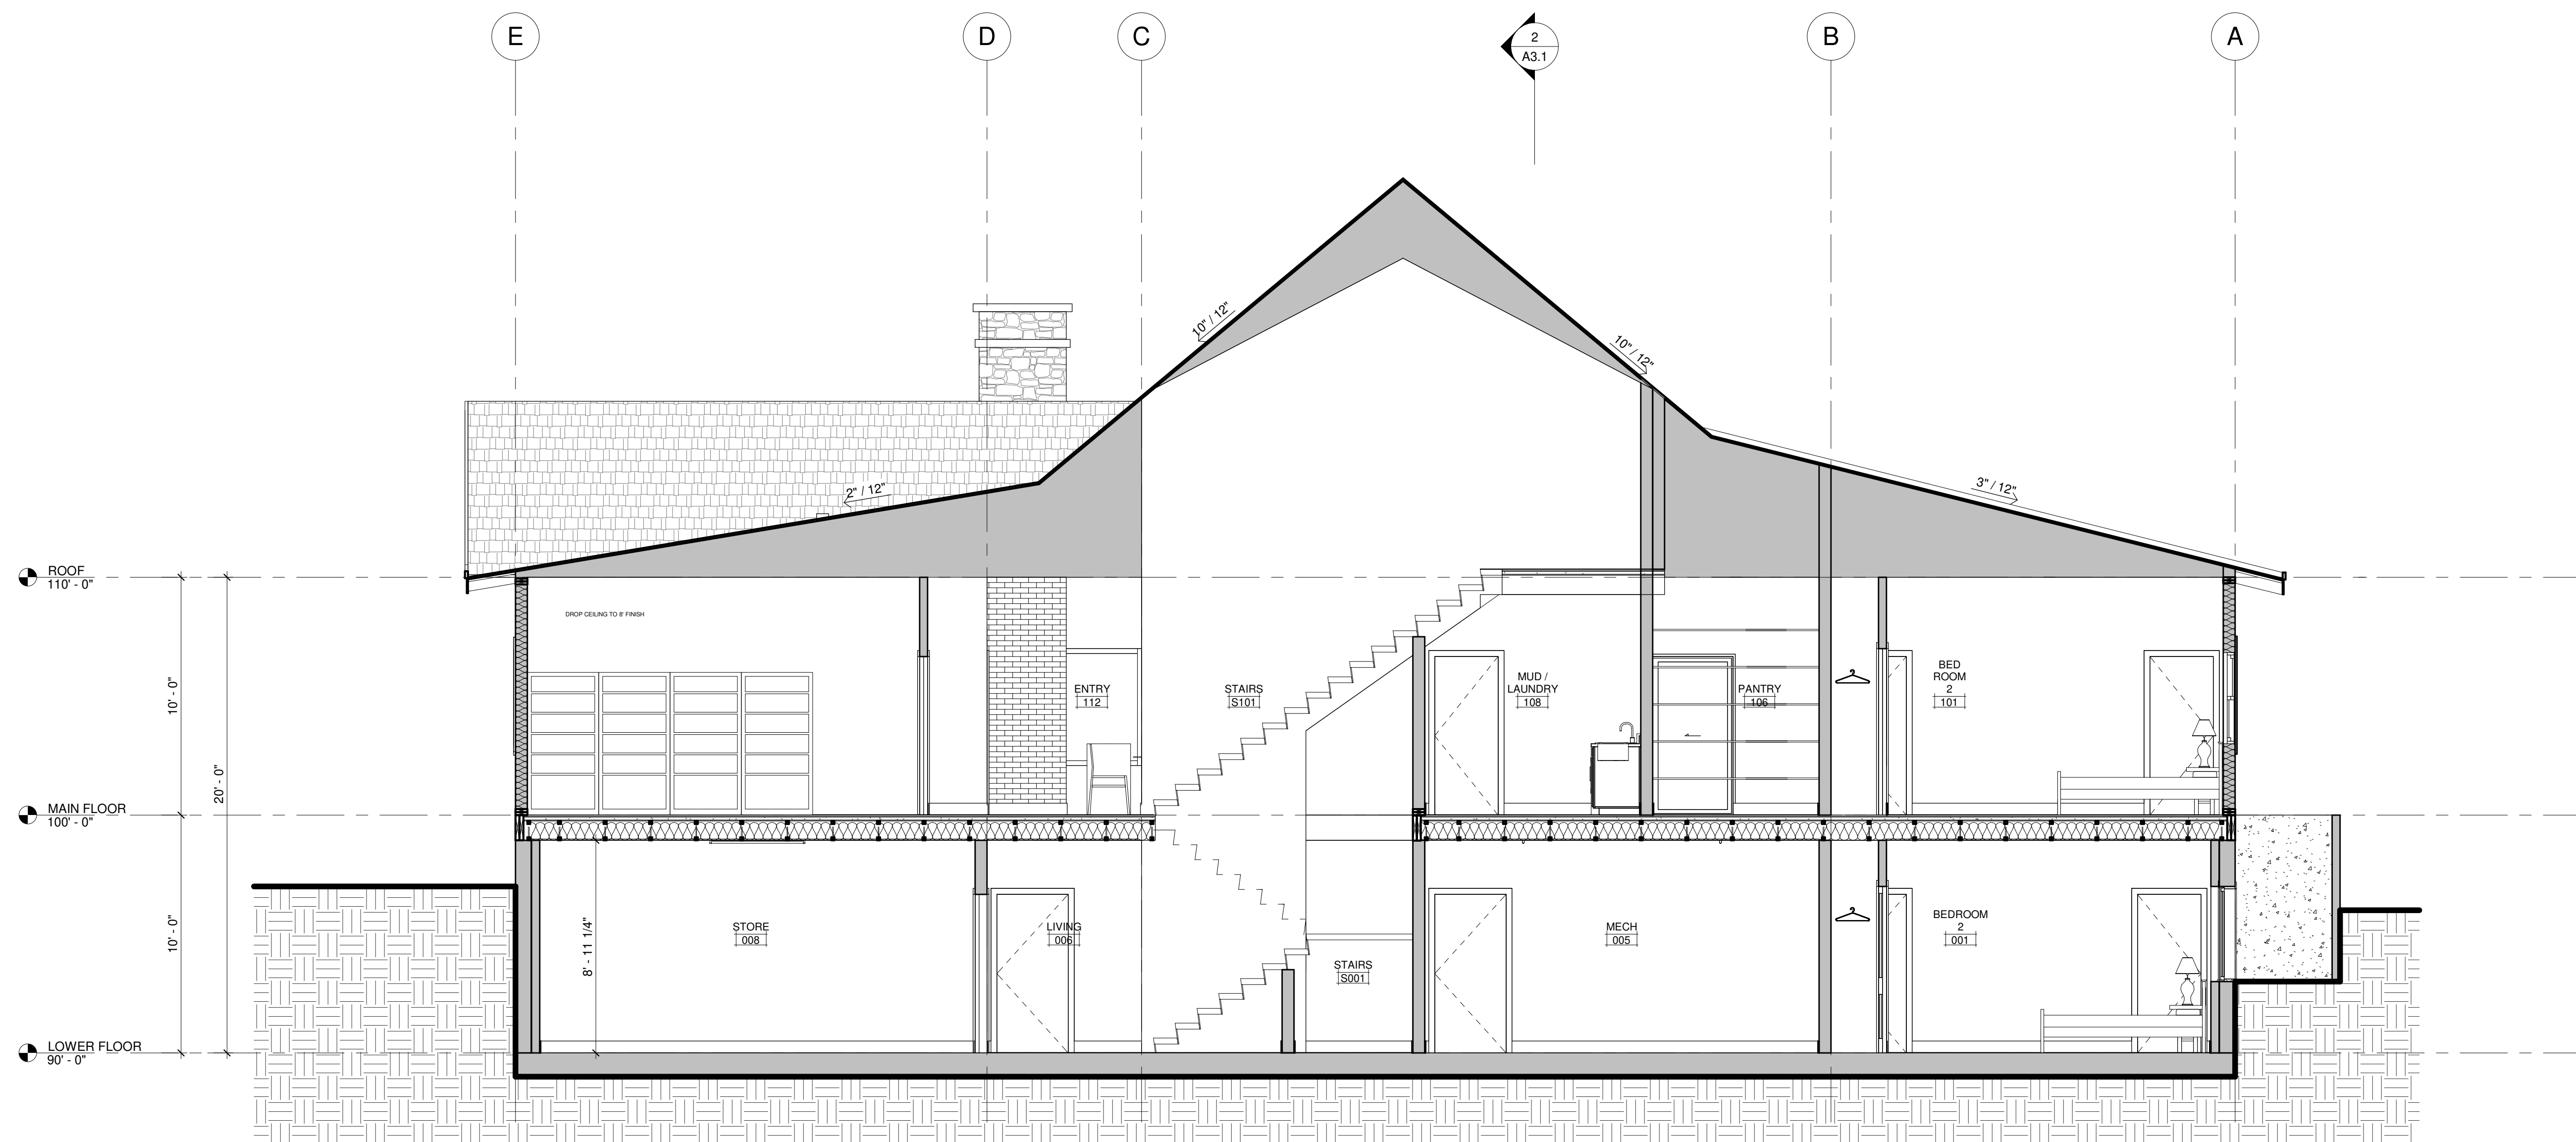


1 STAIRS / BONUS ROOM  
1/4" = 1'-0"

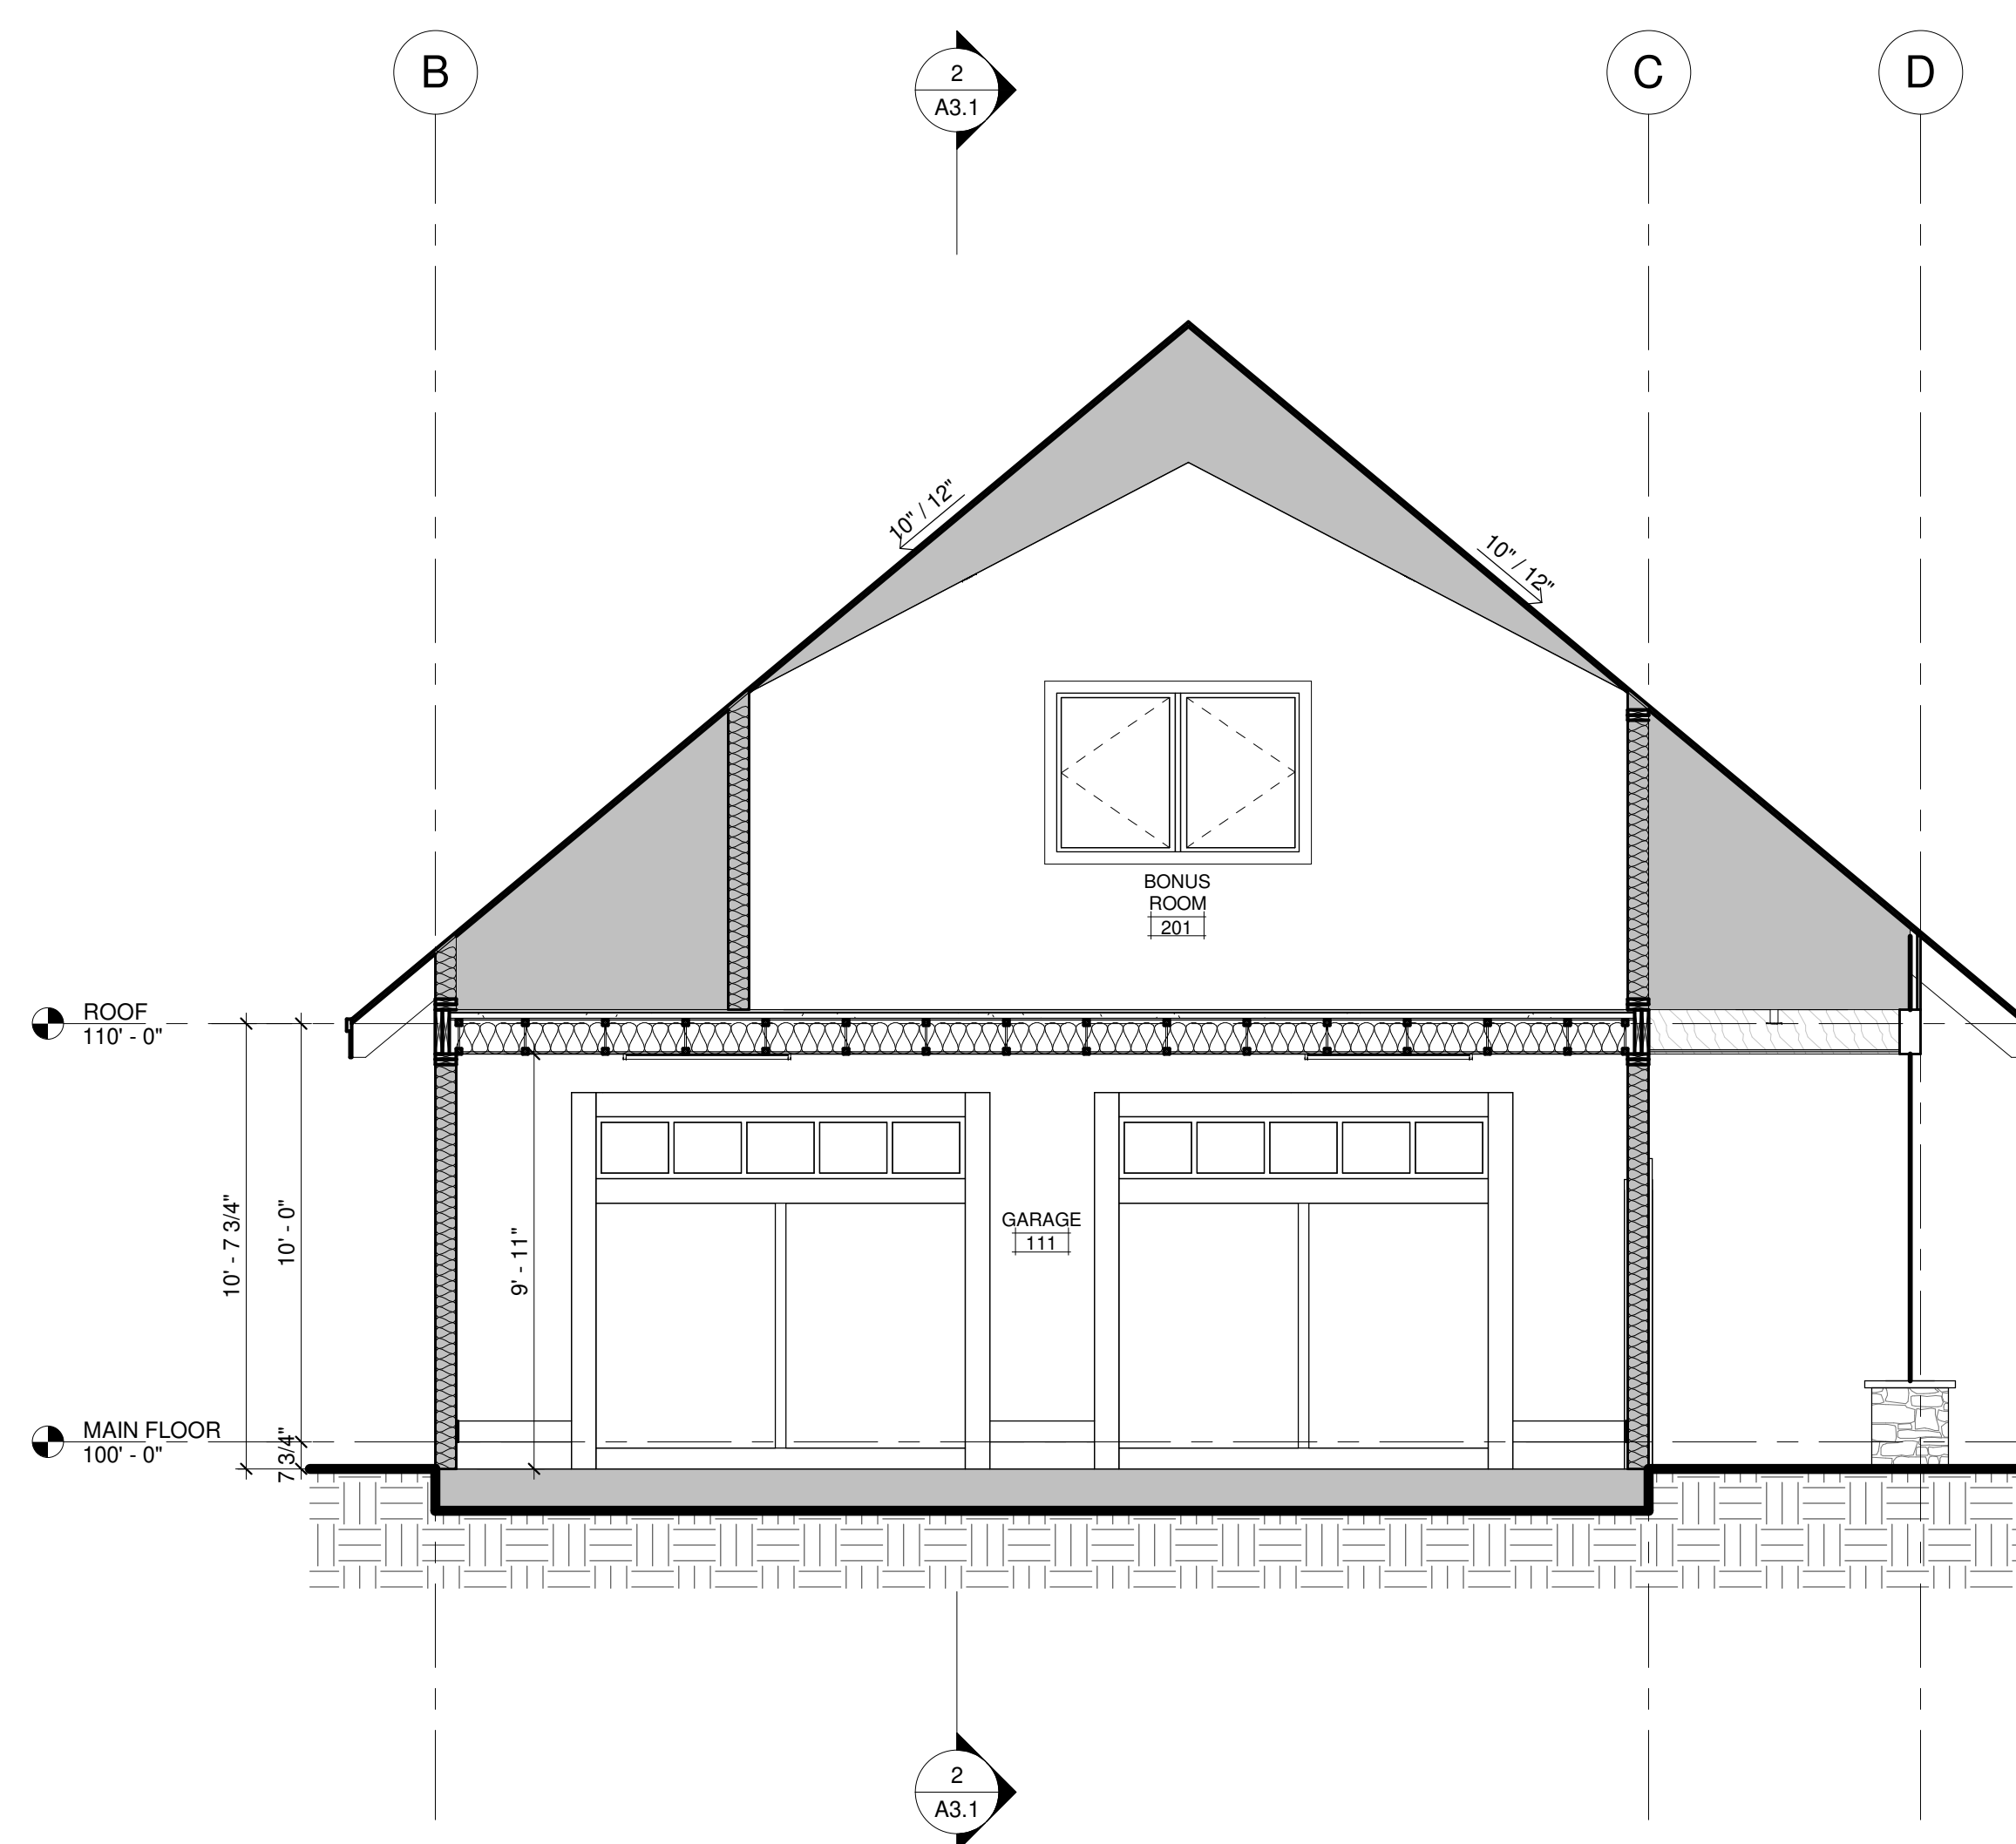


2 BONUS ROOM / GARAGE  
1/4" = 1'-0"

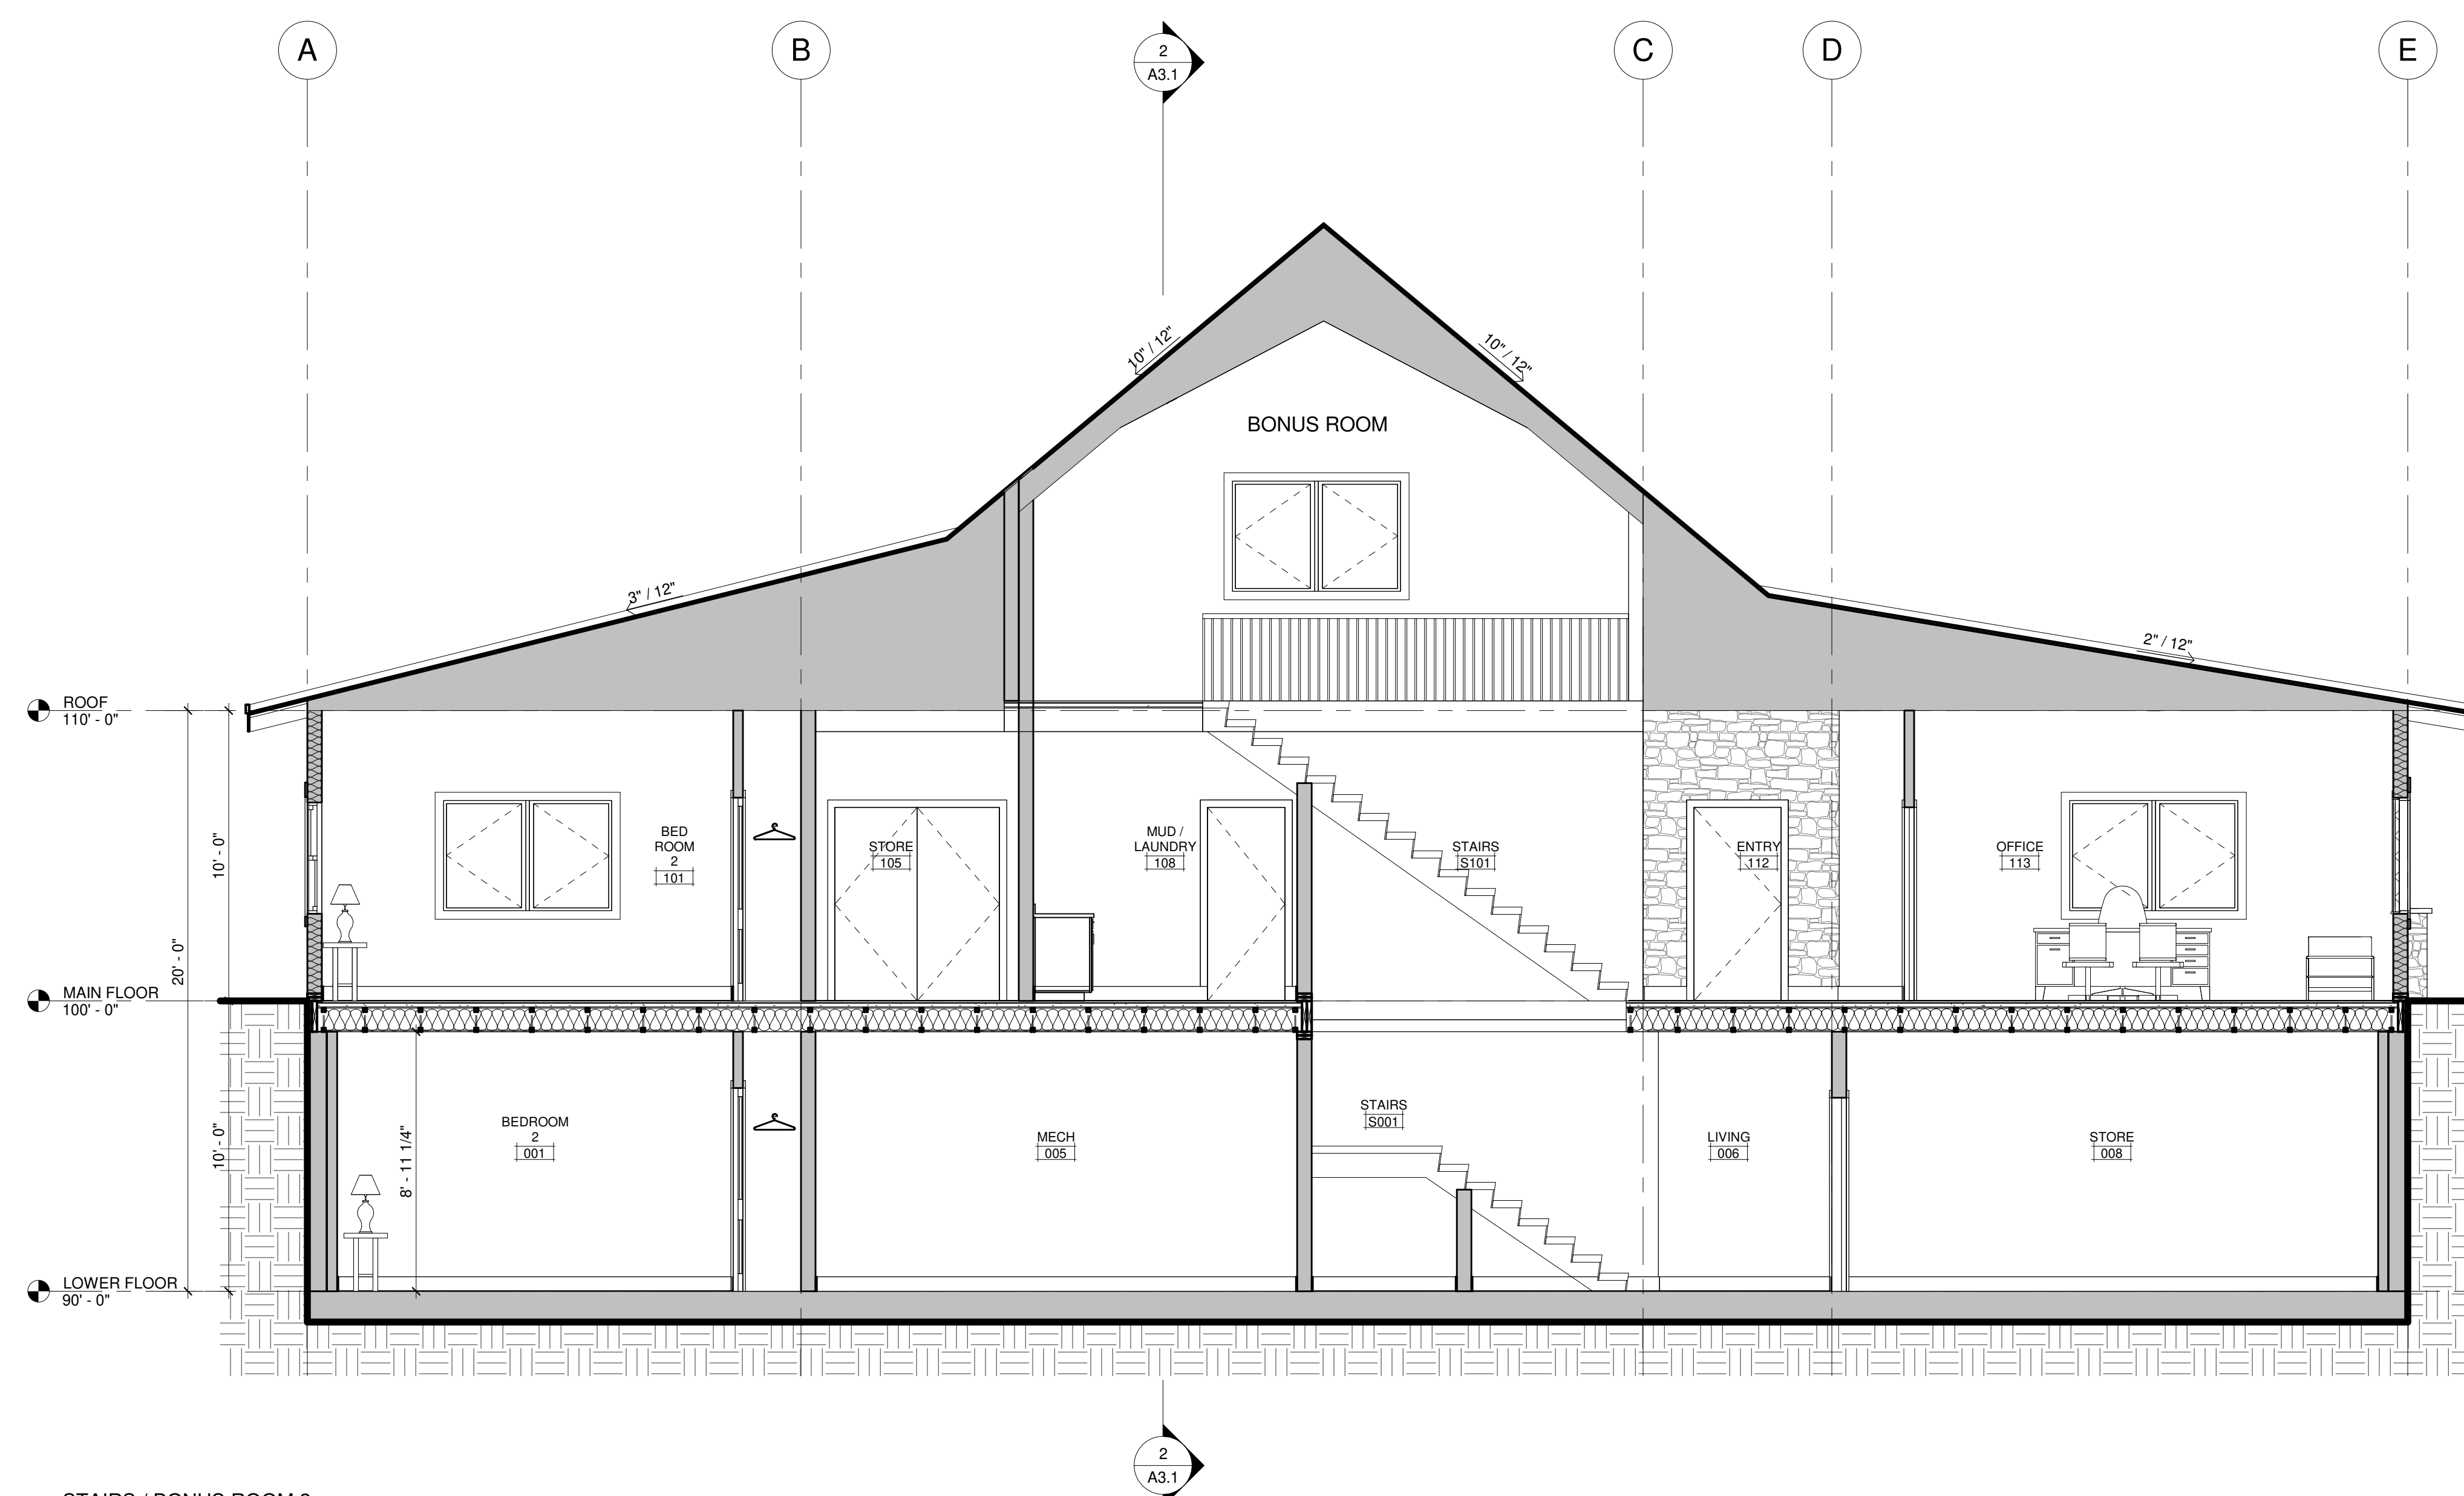

3 STAIRS / BONUS ROOM 2  
1/4" = 1'-0"

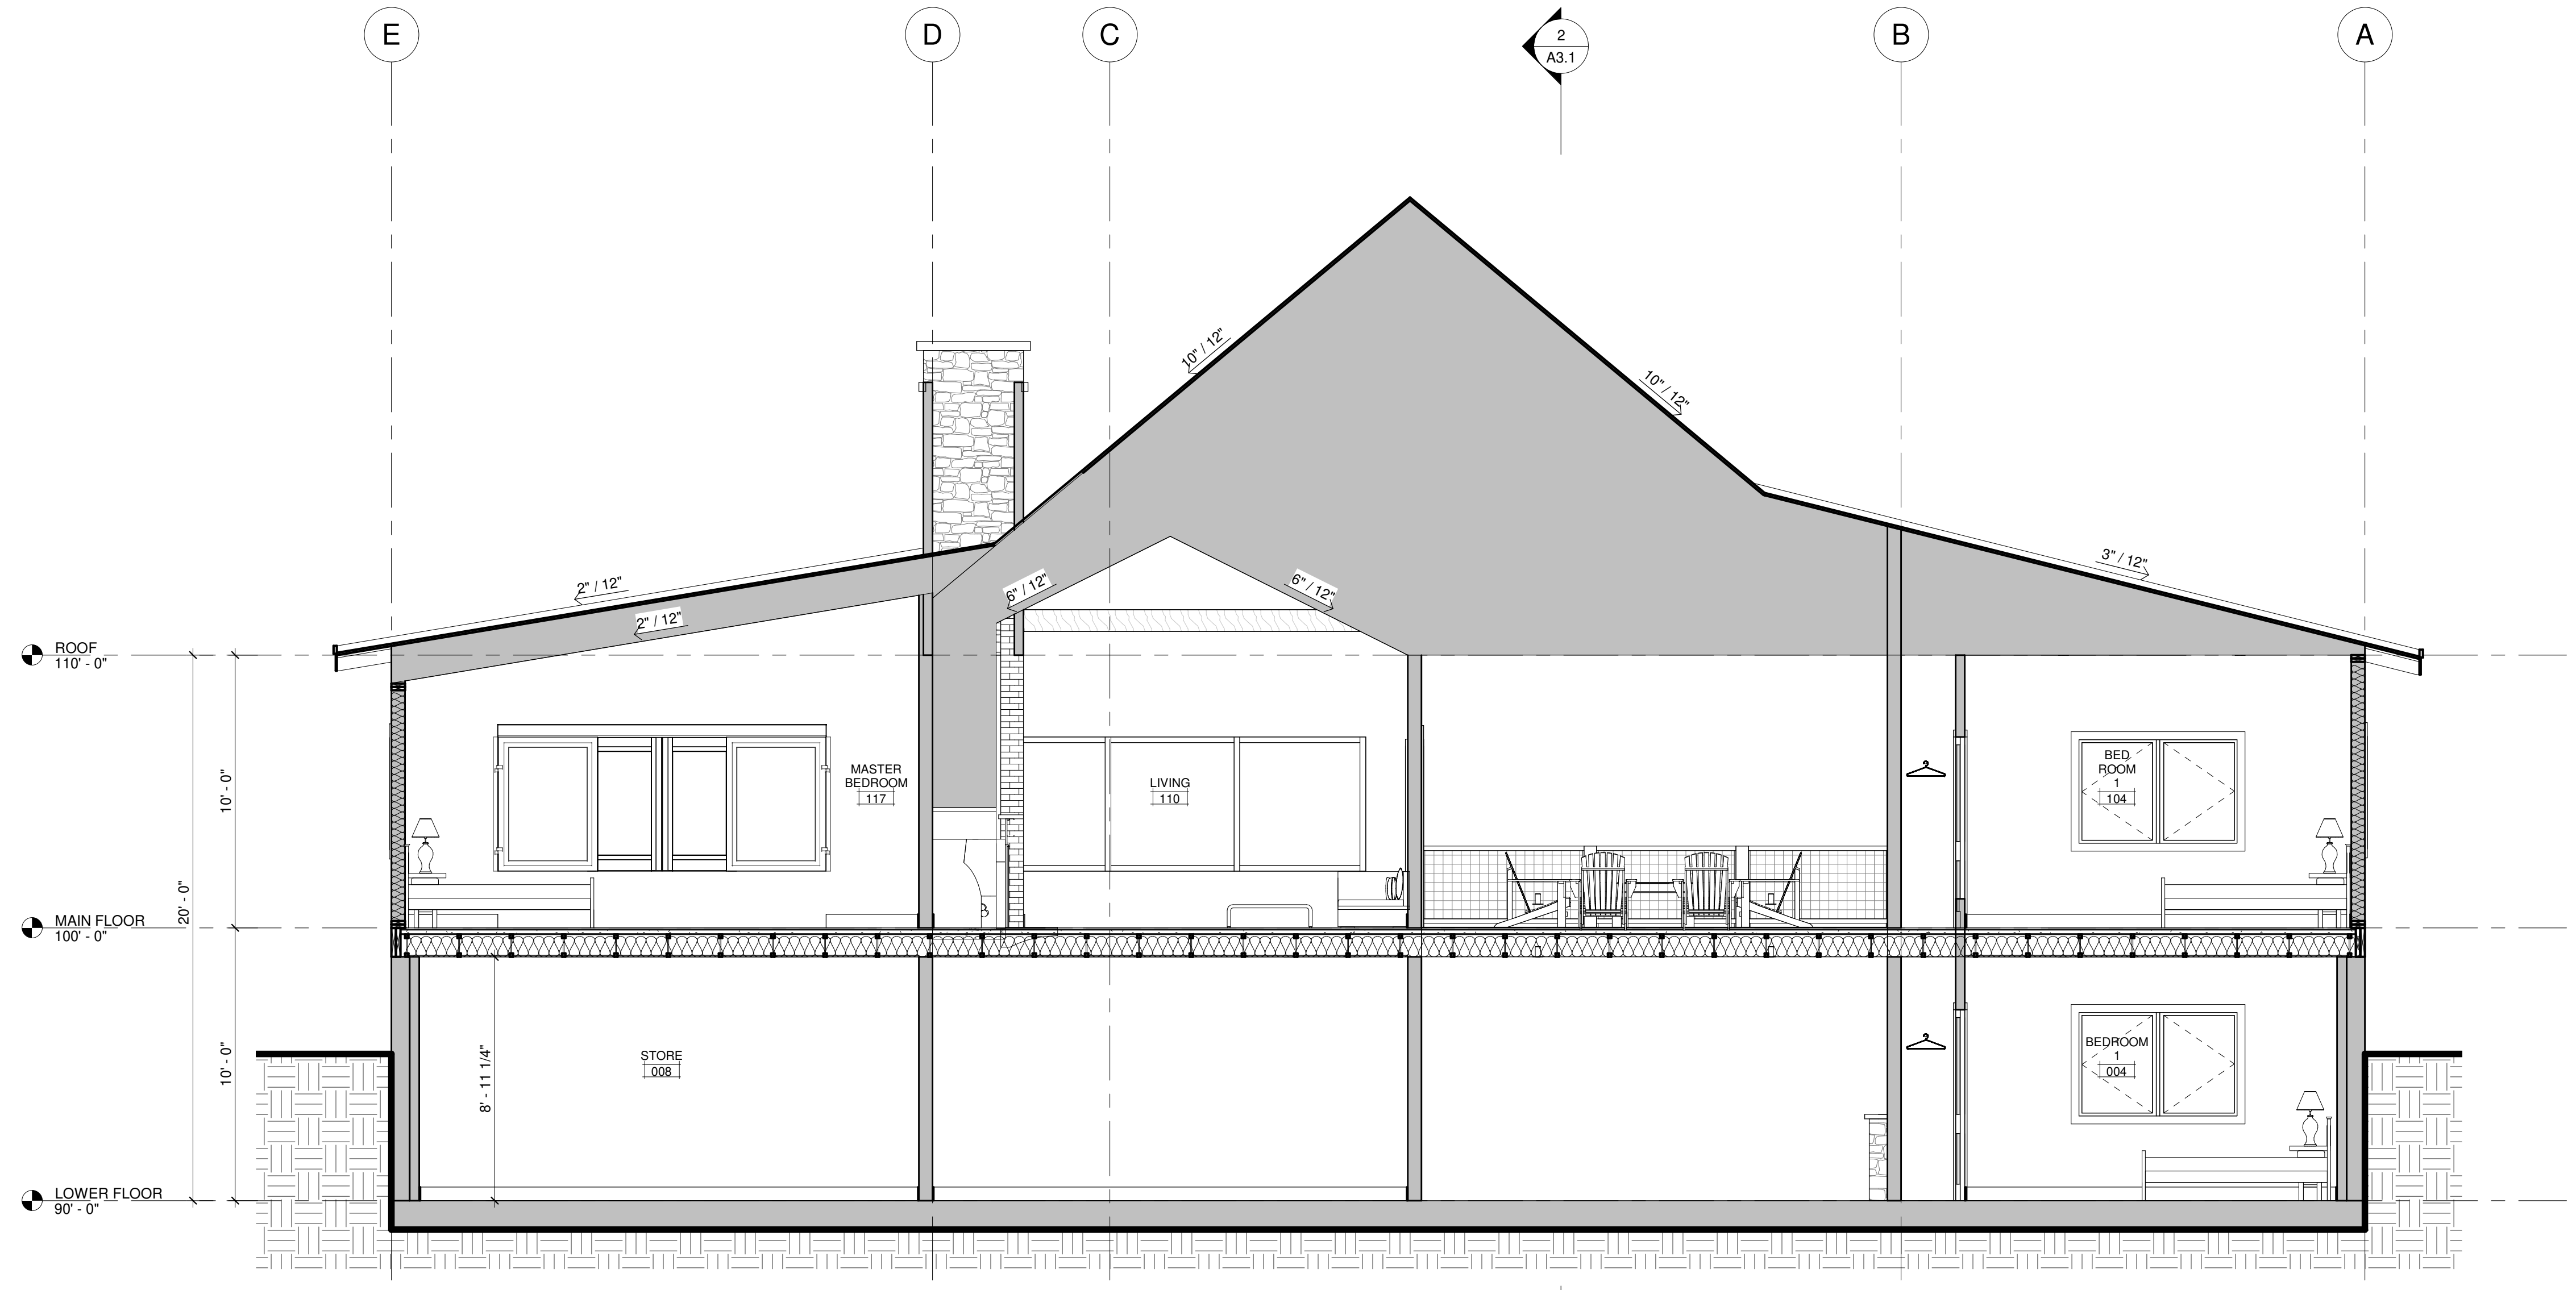

1 MASTER / LIVING  
 1/4" = 1'-0"

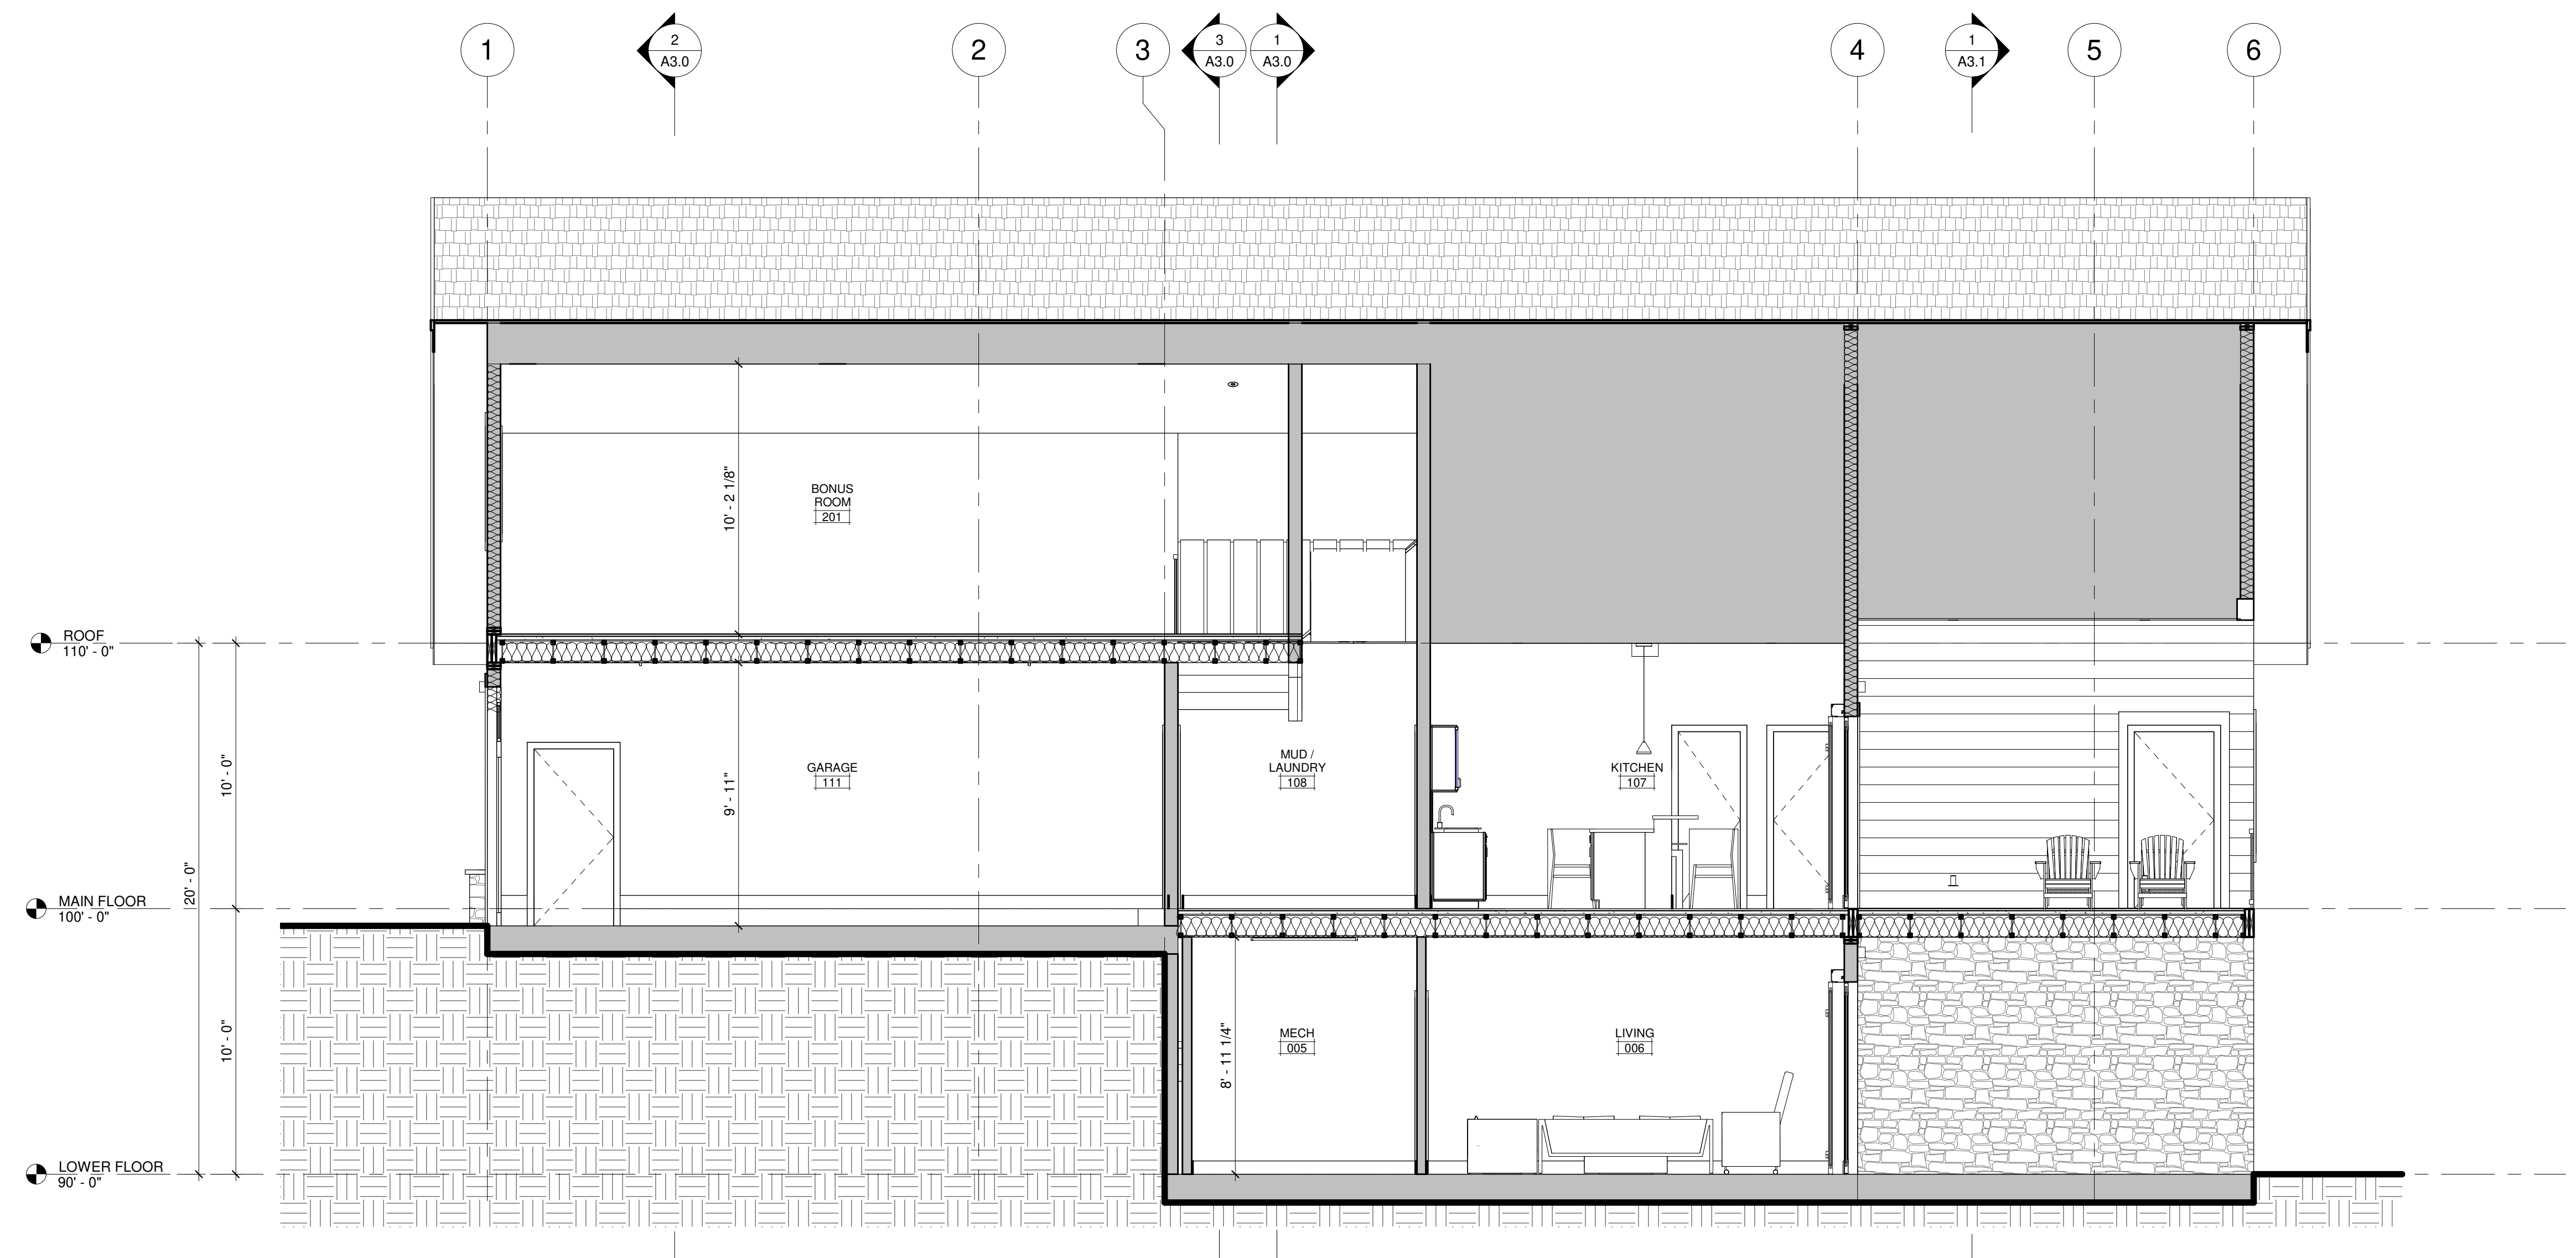

2 GARAGE / STAIRS  
 1/4" = 1'-0"

ARCHITECT'S SEAL :



CHECKED BY : Checker

DRAWN BY : Author

COMMENTS :

REVISION :

No.	Description	Date

8115-GREAT HOUSE PROJECT

TBD

SECTIONS 2

Project Number	##.##
Date	Issue Date
Drawn By	Author
Checked By	Checker

**A3.1**

Scale 1/4" = 1'-0"



ARCHITECT'S SEAL :

DESIGN **efficiently**

CHECKED BY : Checker

DRAWN BY : Author

COMMENTS :

REVISION :




No.	Description	Date

8115-GREAT HOUSE PROJECT

TBD

WINDOW SCHEDULE					
Mark	Width	Sill Height	Head Height	Height	Family
1	6' - 0"	3' - 0"	7' - 0"	4' - 0"	Casement Dbl with Trim
3	2' - 6"	3' - 0"	6' - 10"	3' - 10"	Window-Double-Hung
4	2' - 6"	3' - 0"	6' - 10"	3' - 10"	Window-Double-Hung
5	5' - 0"	3' - 0"	7' - 0"	4' - 0"	Instance - Fixed
6	6' - 0"	3' - 0"	7' - 0"	4' - 0"	Casement Dbl with Trim
7	6' - 0"	3' - 0"	7' - 0"	4' - 0"	Casement Dbl with Trim
8	6' - 0"	3' - 0"	7' - 0"	4' - 0"	Casement Dbl with Trim
9	2' - 6"	3' - 0"	6' - 10"	3' - 10"	Window-Double-Hung
10	2' - 6"	3' - 0"	6' - 10"	3' - 10"	Window-Double-Hung
11	2' - 6"	3' - 0"	6' - 10"	3' - 10"	Window-Double-Hung
12	2' - 6"	3' - 0"	6' - 10"	3' - 10"	Window-Double-Hung
29	6' - 0"	3' - 0"	7' - 0"	4' - 0"	Casement Dbl with Trim
31	2' - 6"	3' - 0"	6' - 10"	3' - 10"	Window-Double-Hung
39	6' - 0"	3' - 0"	7' - 0"	4' - 0"	Casement Dbl with Trim
50	6' - 0"	4' - 0"	8' - 0"	4' - 0"	Casement Dbl with Trim

DOOR SCHEDULE			
Mark	Width	Height	Family
1	3' - 0"	6' - 8"	Single-Flush
2	12' - 0 1/2"	4' - 11"	ADS BP 2+2-SD-001 5'
3	3' - 0"	6' - 8"	Single-Flush
4	10' - 0 1/2"	7' - 3"	ADS BP 2+2-SD-001
5	3' - 0"	6' - 8"	Single-Flush
006	10' - 0 1/2"	7' - 3"	ADS BP 2+2-SD-001
95	6' - 0"	7' - 0"	Sliding-Closet
96	6' - 0"	7' - 0"	Sliding-Closet
97	6' - 0"	7' - 0"	Sliding-Closet
98	6' - 0"	7' - 0"	Sliding-Closet
105	5' - 8"	6' - 8"	Double-Flush
108	2' - 8"	6' - 8"	Single-Flush
111A	10' - 0"	9' - 0"	Garage Door
111B	10' - 0"	9' - 0"	Garage Door
ID006	2' - 10"	6' - 8"	Single-Flush
ID 001	2' - 10"	6' - 8"	Single-Flush
ID 002	2' - 8"	6' - 8"	Single-Flush
ID 003	2' - 8"	6' - 8"	Single-Flush
ID 004	2' - 10"	6' - 8"	Single-Flush
ID 005	3' - 0"	6' - 8"	Single-Flush
ID 007	3' - 0"	6' - 8"	Single-Flush
ID 008	3' - 0"	6' - 8"	Single-Flush
ID 101	2' - 10"	6' - 8"	Single-Flush
ID 102	2' - 8"	6' - 8"	Single-Flush
ID 103	2' - 8"	6' - 8"	Single-Flush
ID 104	2' - 10"	6' - 8"	Single-Flush
ID 106	2' - 6"	6' - 8"	Doors_Sliding_UFME_Porte-Fenetre_Galandage_1V
ID 108	2' - 8"	6' - 8"	Single-Flush
ID 113	2' - 10"	6' - 8"	Single-Flush
ID 114	2' - 6"	6' - 8"	Doors_Sliding_UFME_Porte-Fenetre_Galandage_1V
ID 116	2' - 4"	6' - 8"	Single-Flush
ID 117	2' - 10"	6' - 8"	Single-Flush
ID 118	2' - 8"	6' - 8"	Single-Flush
ID 119	2' - 4"	6' - 8"	Single-Flush
SD	2' - 6"	7' - 8"	Curtain Wall Sgl Glass
SD	2' - 6"	7' - 7 1/2"	Curtain Wall Sgl Glass
SD	2' - 6"	7' - 8"	Curtain Wall Sgl Glass
SD	2' - 6"	7' - 7 1/2"	Curtain Wall Sgl Glass

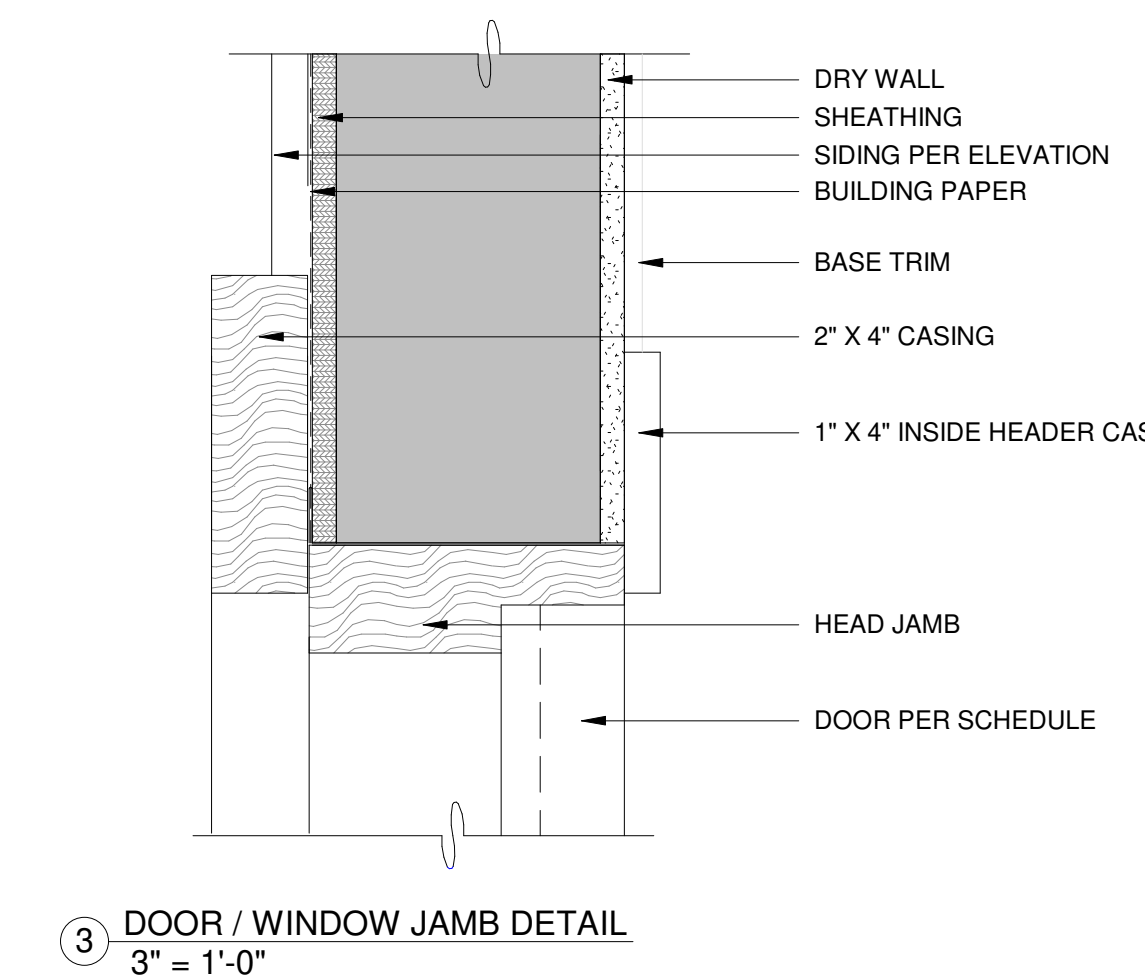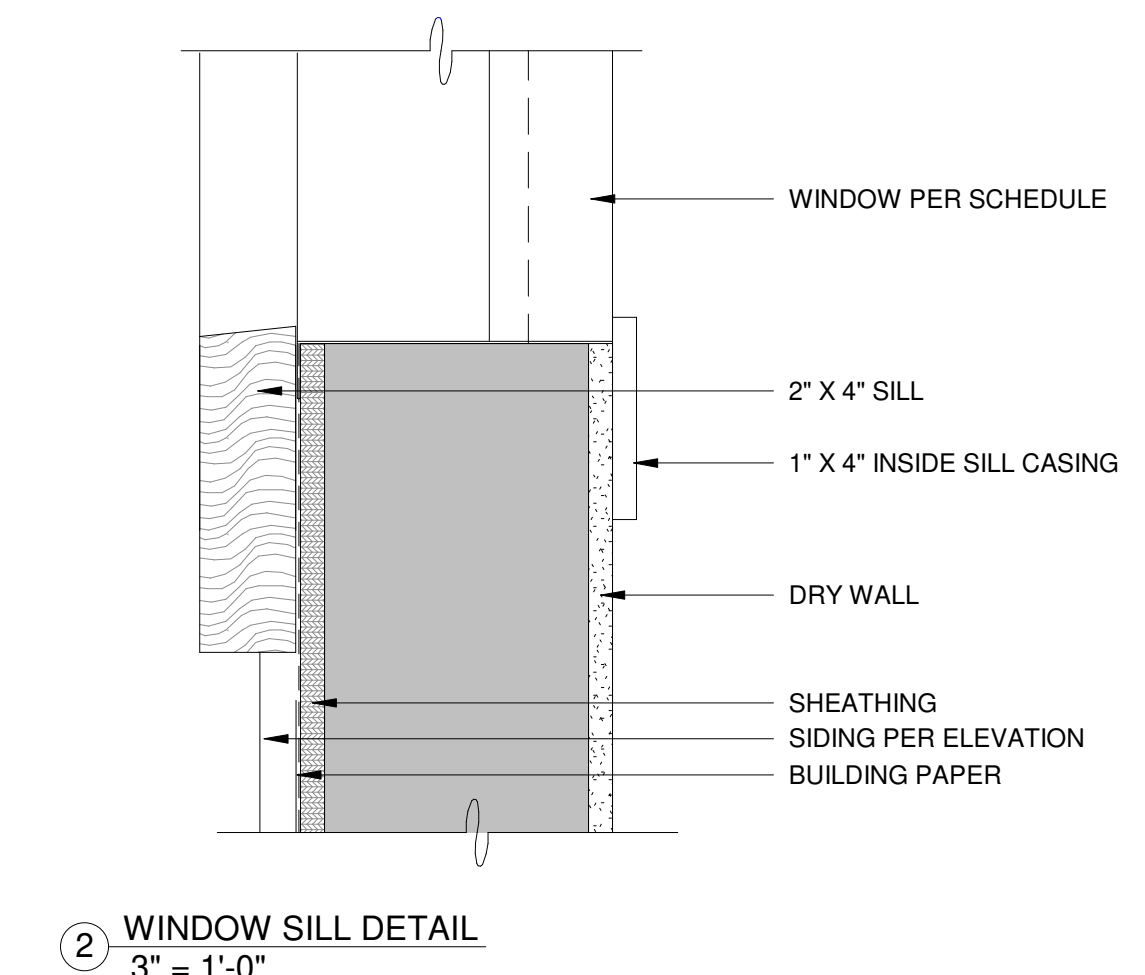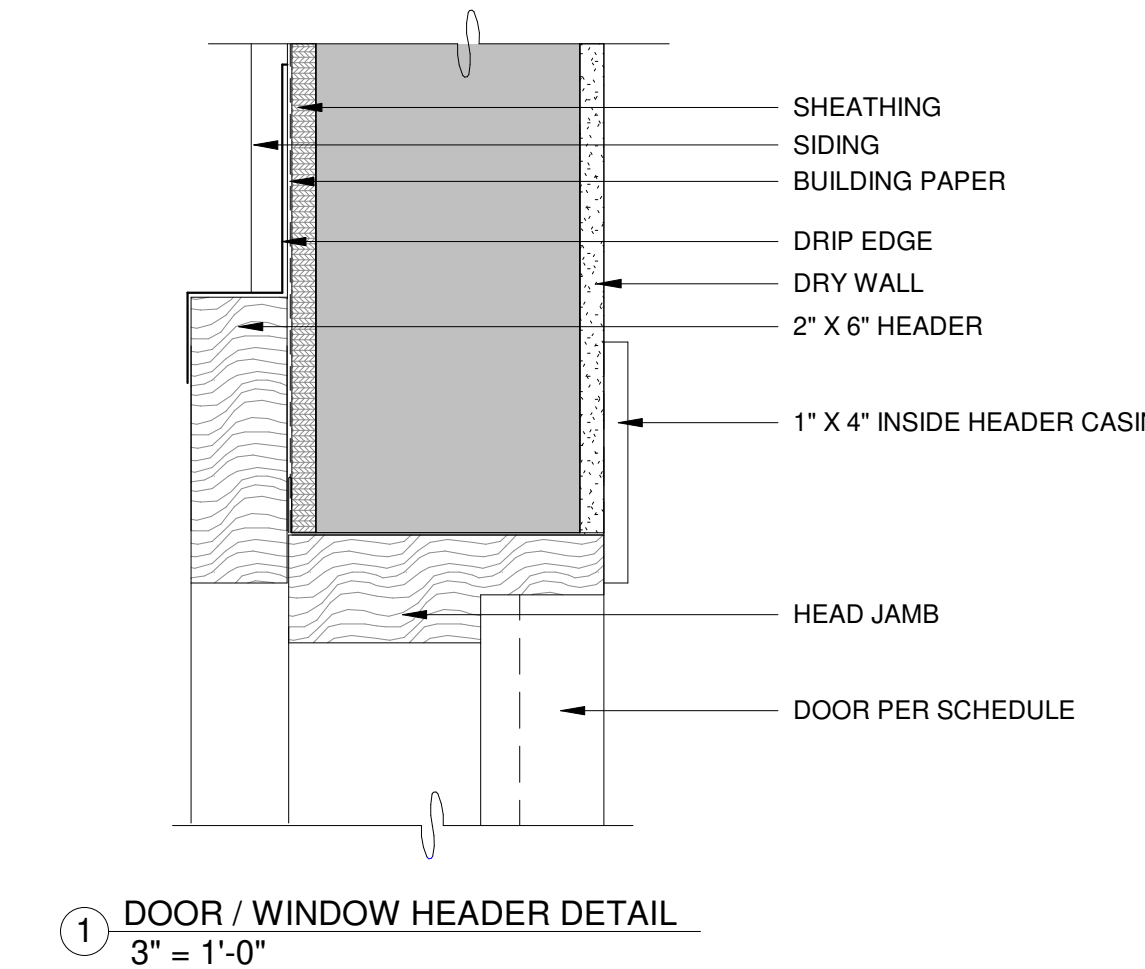


NOTE:  
 1) ALL BASE TRIM IS 1" X 6" WOOD OVER THE FLOORING THAT IS NOT TILE.  
 2) IN THE AREAS WHERE THE FLOORING IS TILE, THE BASE TRIM WOULD ALSO BE OF THE SAME TILE MATERIAL WHICH IS 6" IN HEIGHT.  
 3) ALL DOOR AND WINDOW CASING IS 1" X 4" WOOD.

DOOR AND WINDOW DETAILS


Project Number	###
Date	Issue Date
Drawn By	Author
Checked By	Checker

A4.0


Scale	3" = 1'-0"
-------	------------

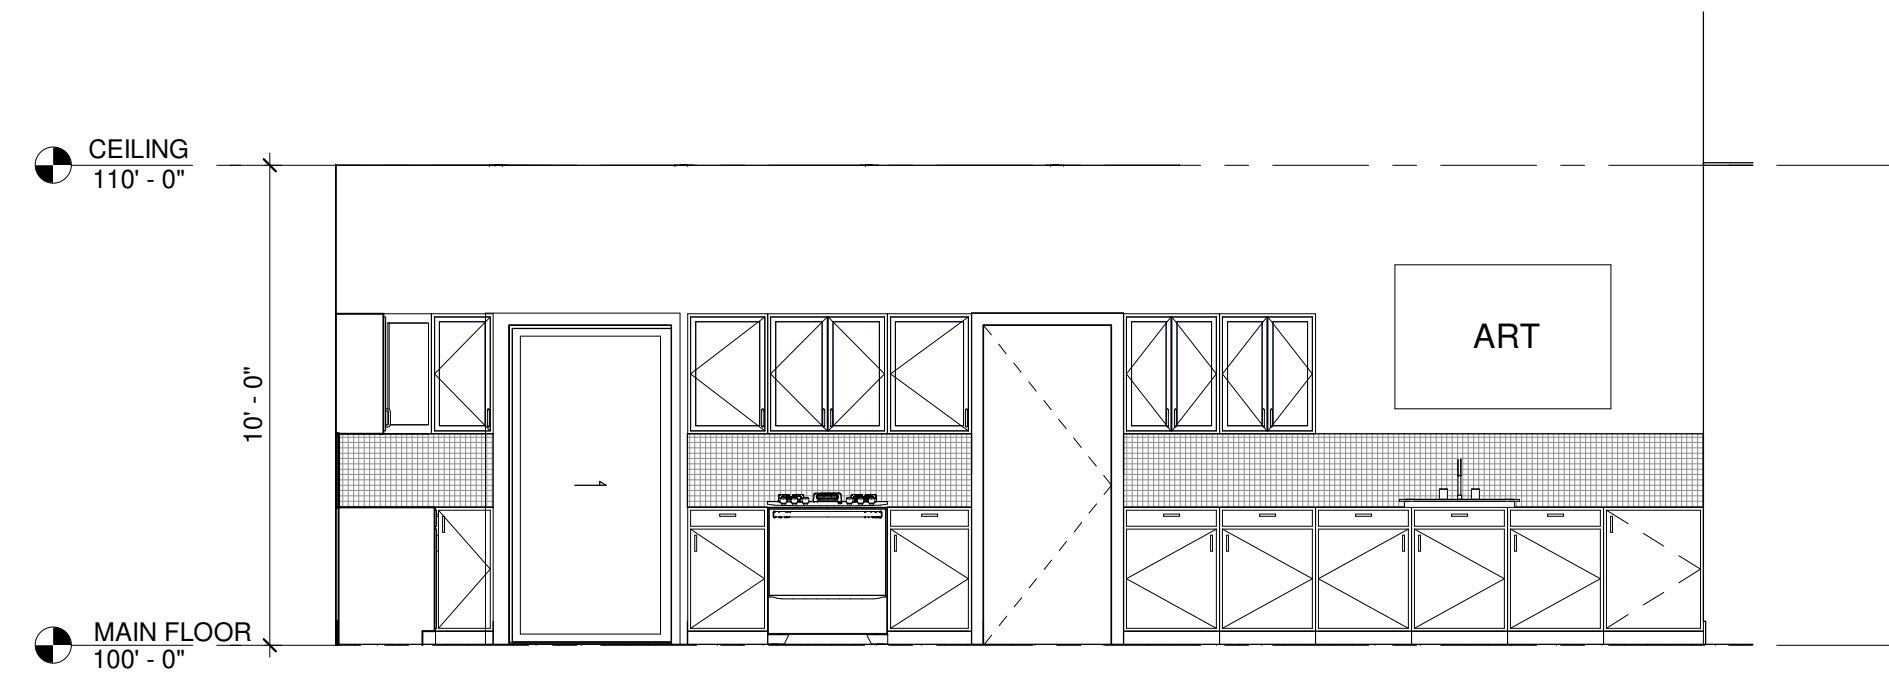


1 107-KITCHEN-NORTH  
1/4" = 1'-0"

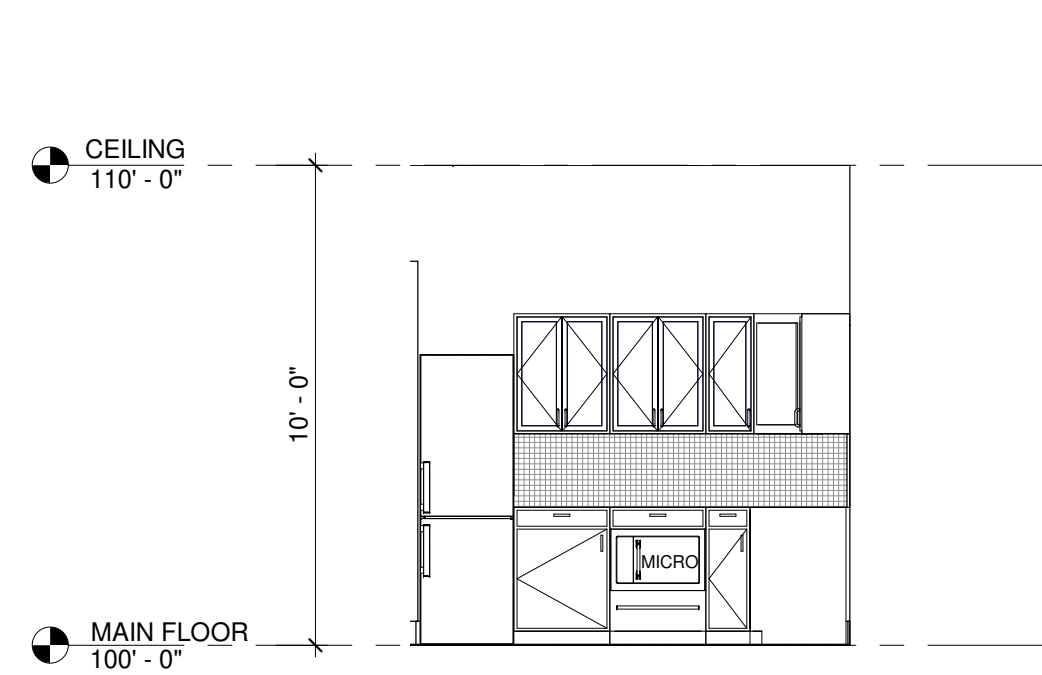


2 107-KITCHEN-WEST  
1/4" = 1'-0"

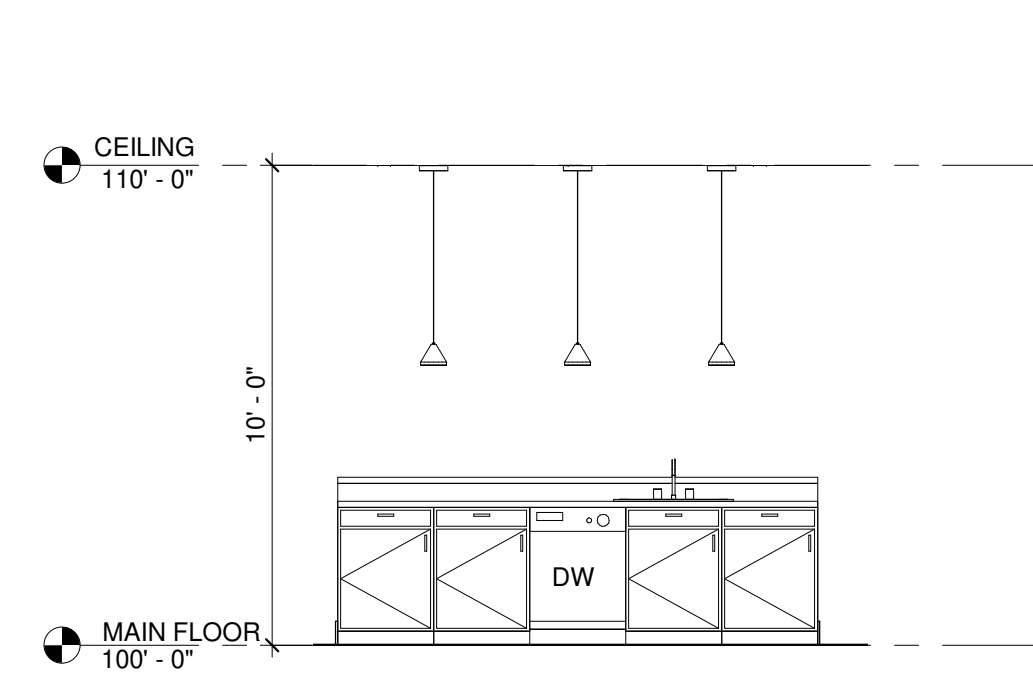


14 107-KITCHEN ISLAND-SOUTH  
1/4" = 1'-0"

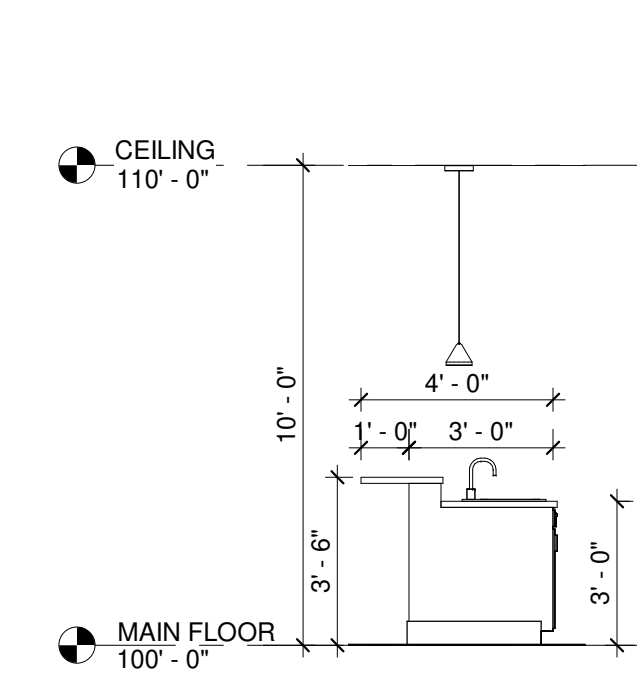


22 107-KITCHEN ISLAND-EAST  
1/4" = 1'-0"

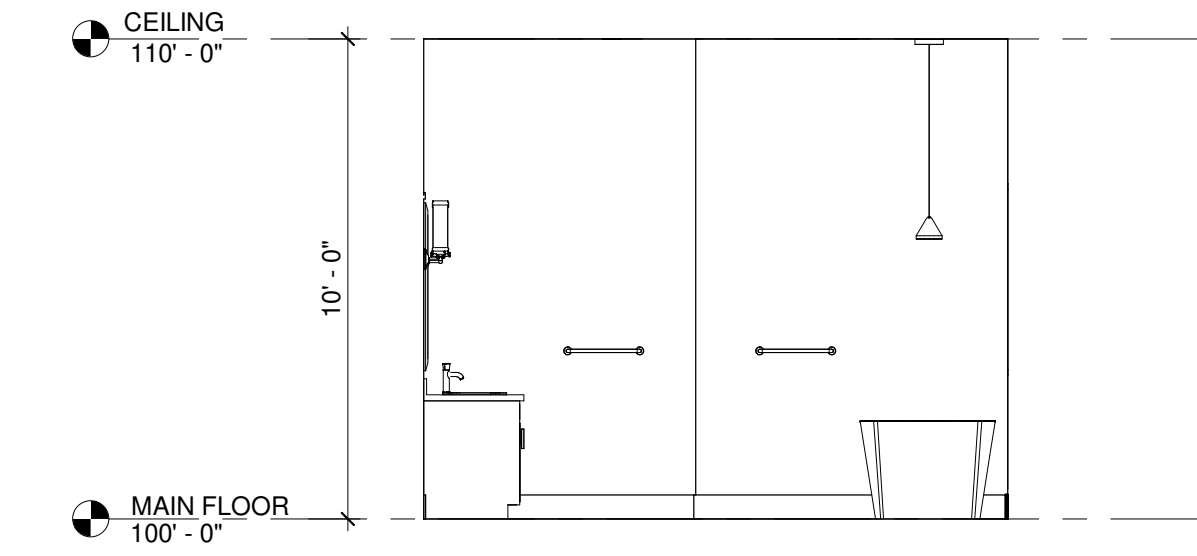


3 118-MASTER BATH-NORTH  
1/4" = 1'-0"

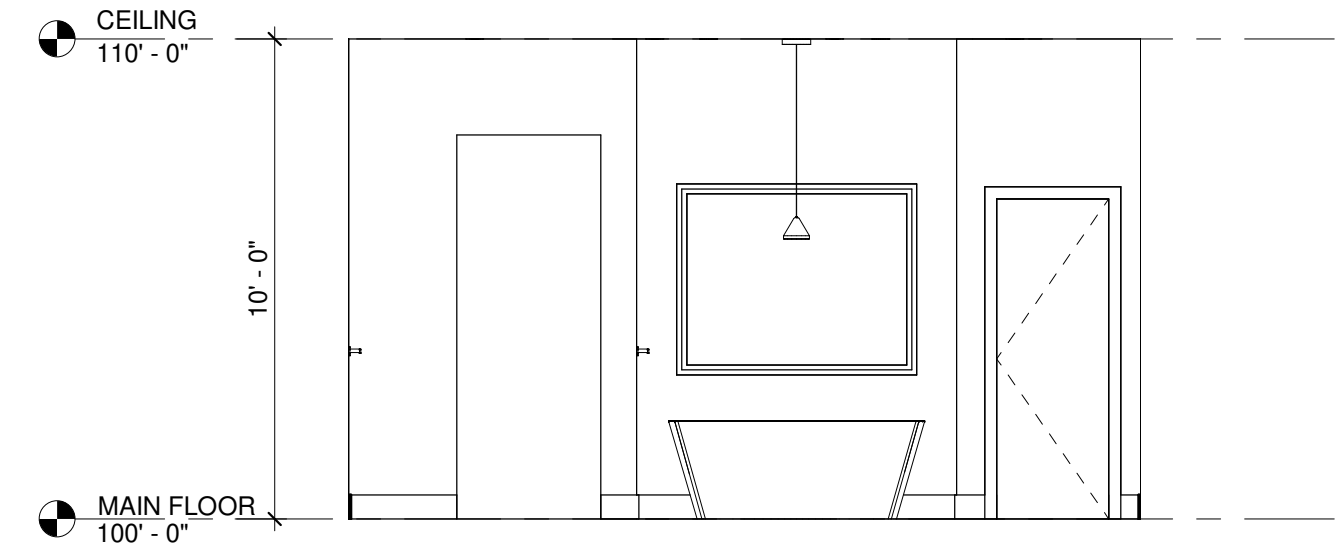


4 118-MASTER BATH-EAST  
1/4" = 1'-0"

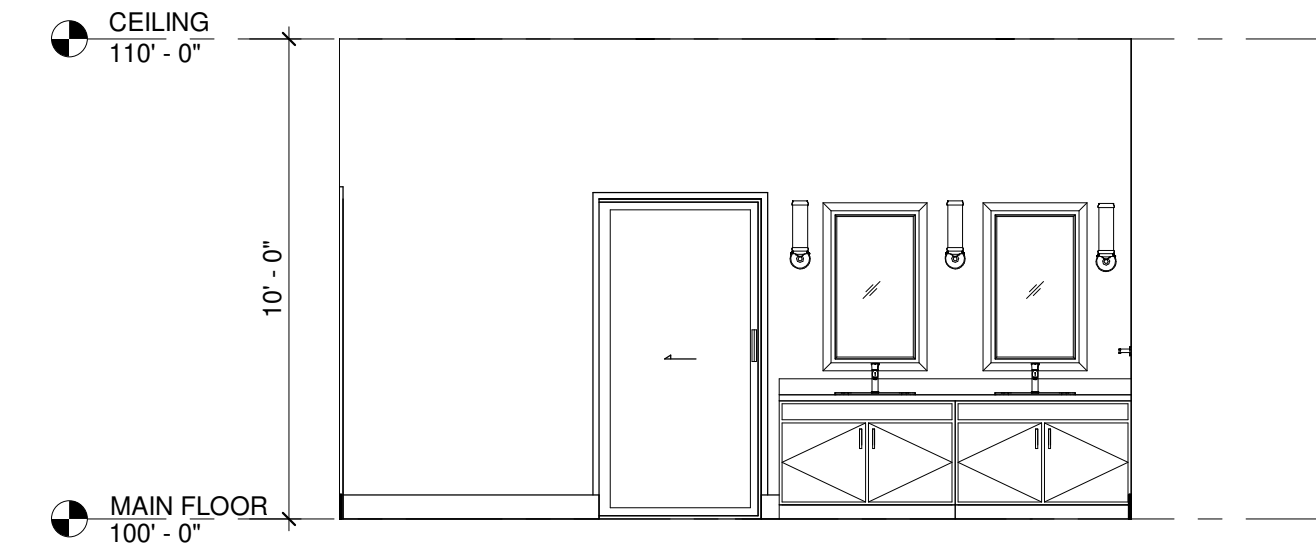


5 118-MASTER BATH-WEST  
1/4" = 1'-0"

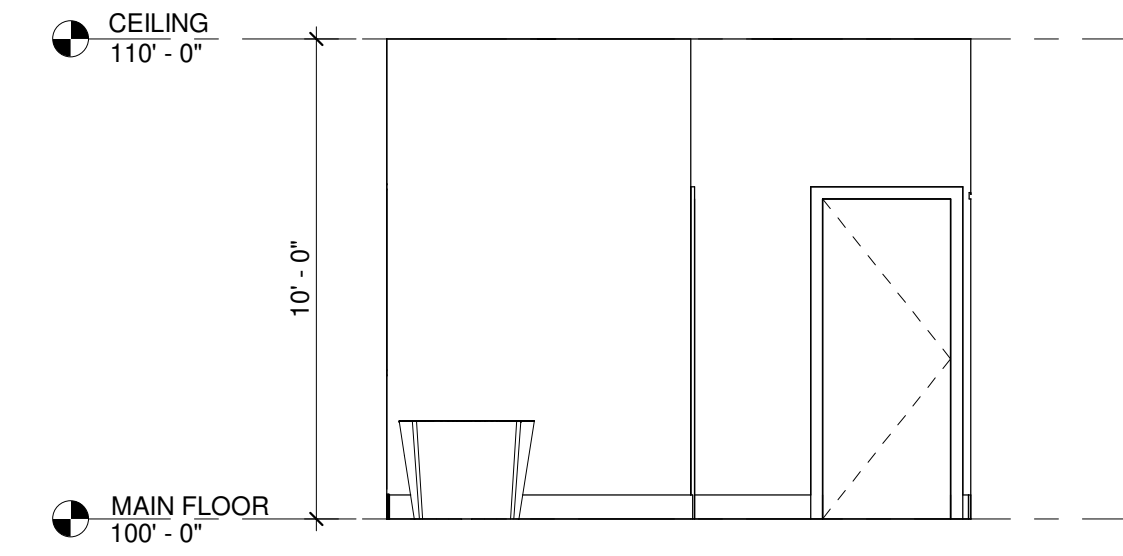


6 118-MASTER BATH-SOUTH  
1/4" = 1'-0"

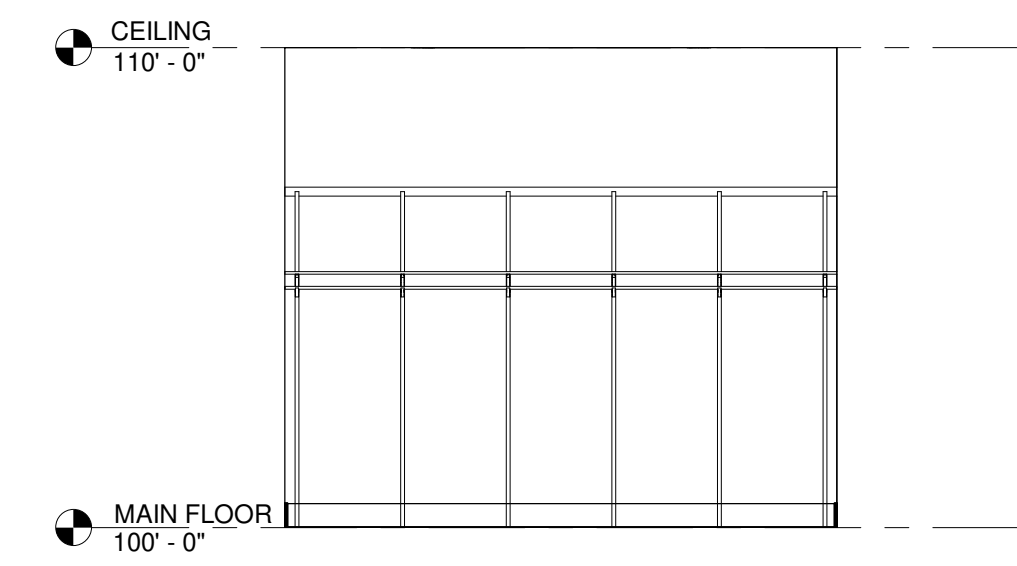


7 114-WALK IN CLOSET-WEST  
1/4" = 1'-0"

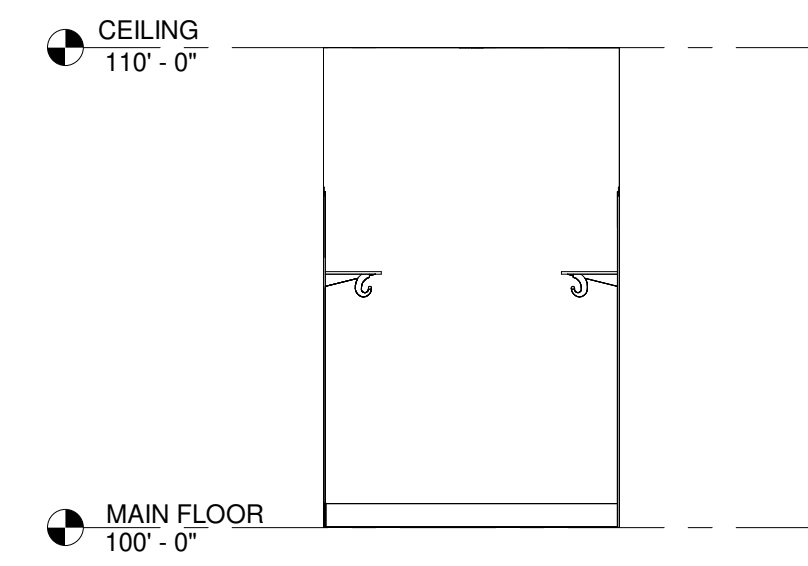


8 114-WALK IN CLOSET-NORTH  
1/4" = 1'-0"

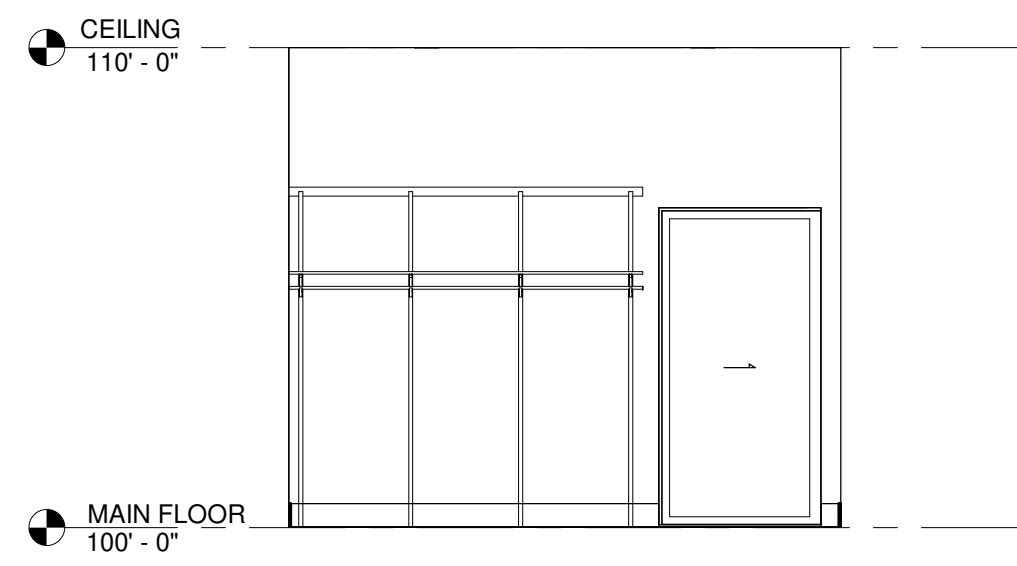


9 114-WALK IN CLOSET-EAST  
1/4" = 1'-0"

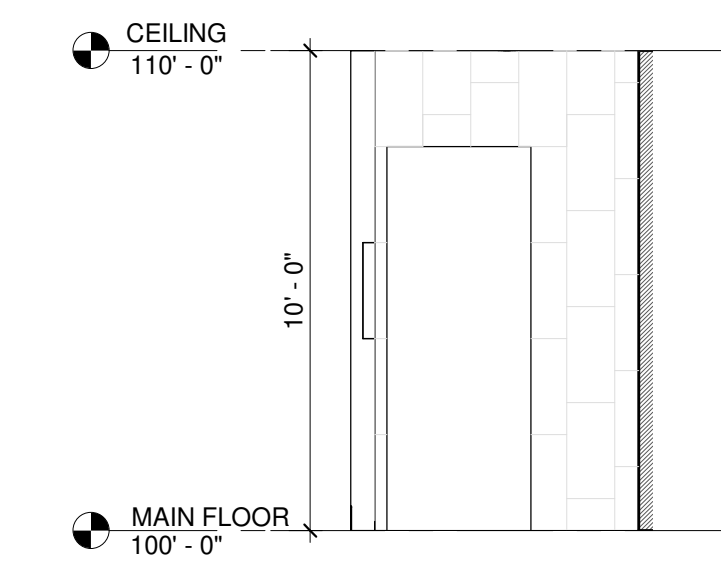


10 115-MASTER BATH SHOWER-WEST  
1/4" = 1'-0"

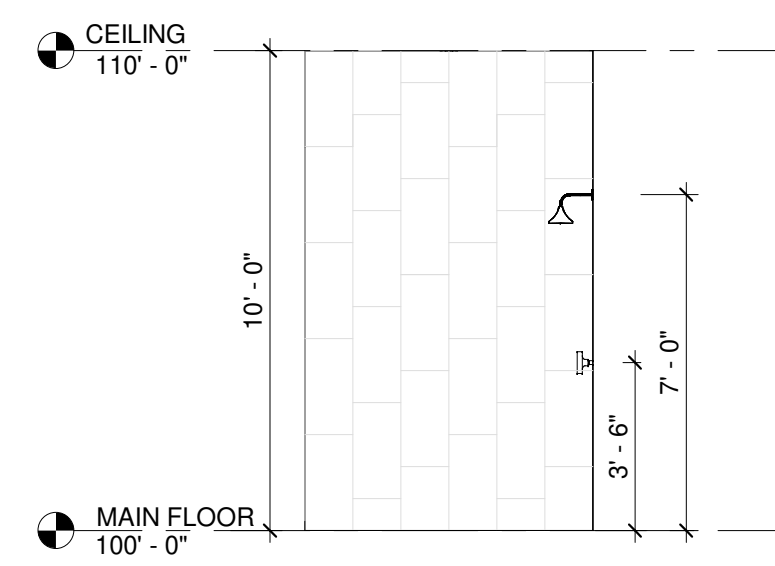


11 115-MASTER BATH SHOWER-NORTH  
1/4" = 1'-0"

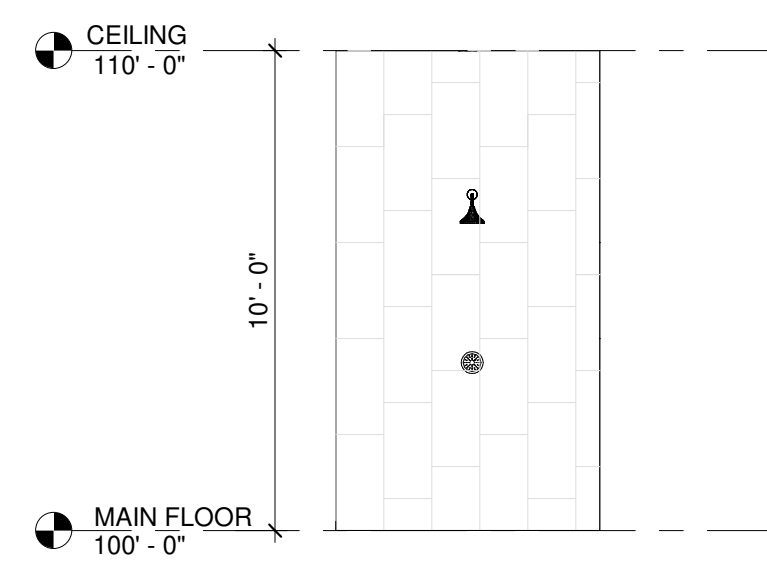


12 115-MASTER BATH SHOWER-EAST  
1/4" = 1'-0"

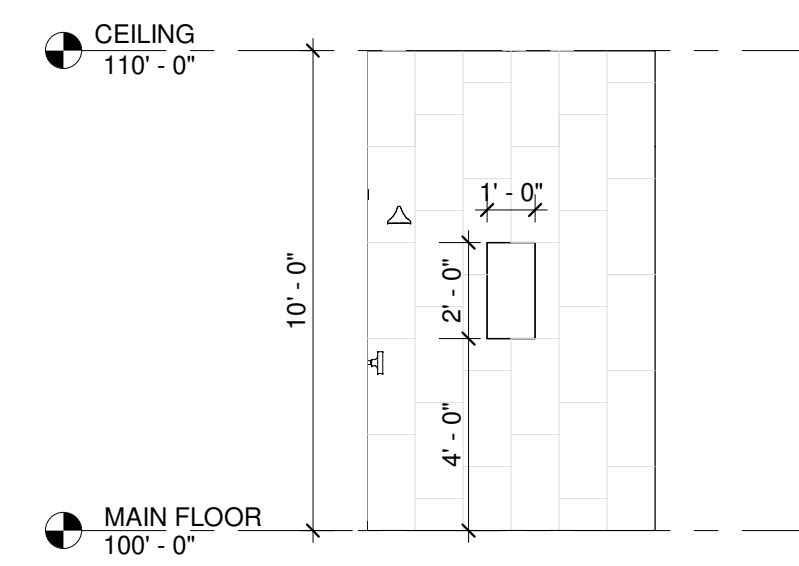


13 115-MASTER BATH SHOWER-SOUTH  
1/4" = 1'-0"

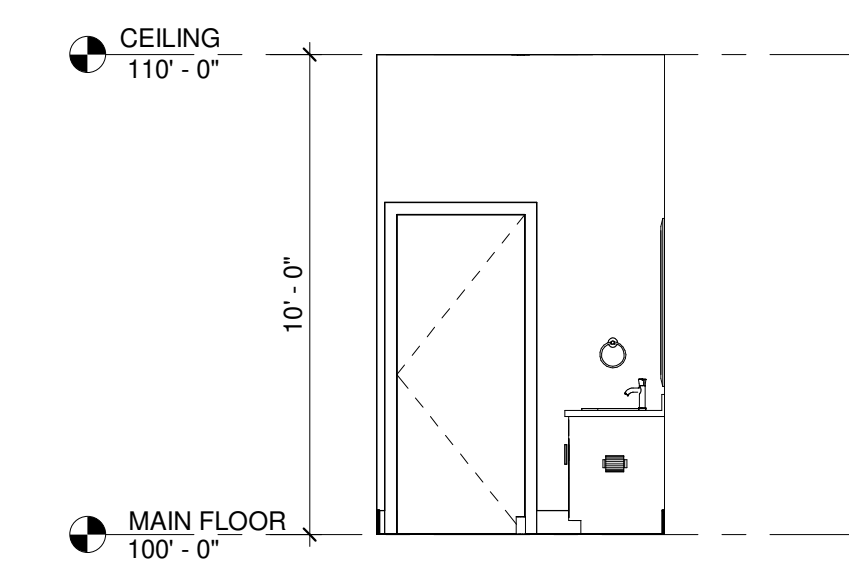


15 102-TYPICAL BATH-NORTH  
1/4" = 1'-0"

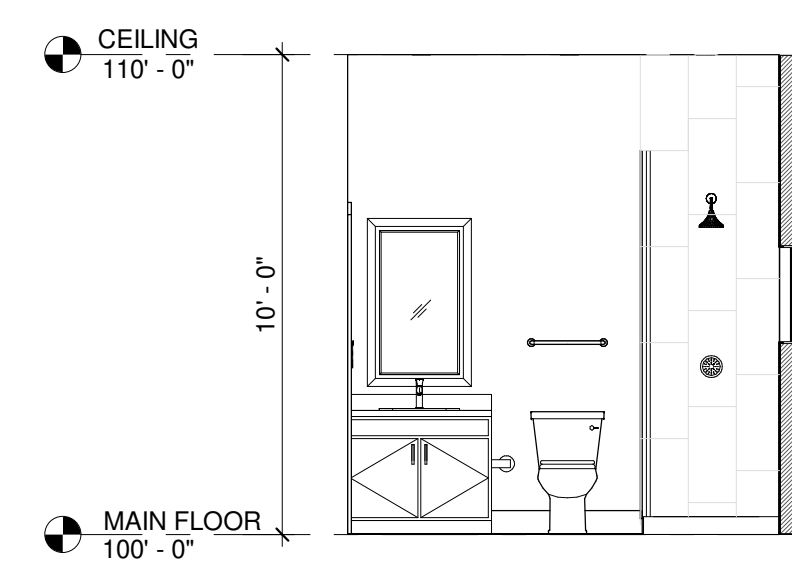


16 102-TYPICAL BATH-EAST  
1/4" = 1'-0"

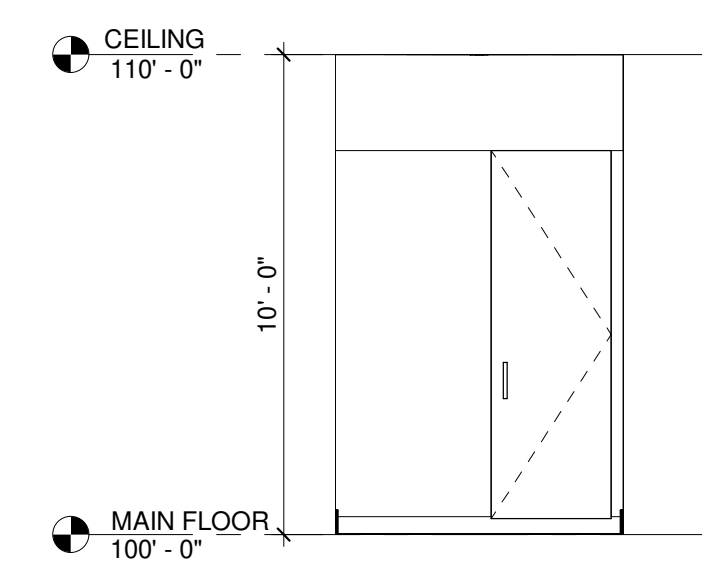

17 102-TYPICAL BATH-SOUTH  
1/4" = 1'-0"

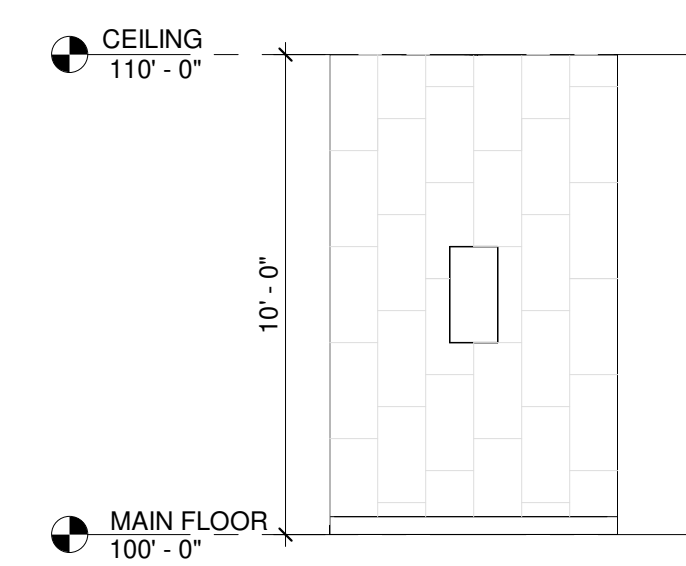

20 102-BATH SHOWER-SOUTH  
1/4" = 1'-0"

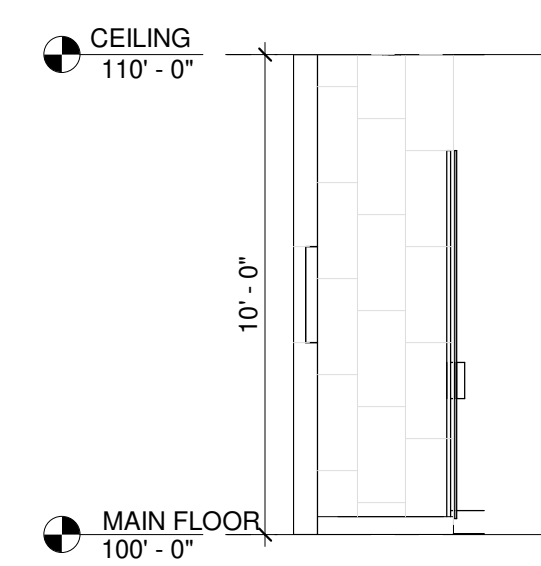

21 102-BATH SHOWER-WEST  
1/4" = 1'-0"

ARCHITECT'S SEAL :

DESIGN .efficiently

CHECKED BY : Checker

DRAWN BY : Author

COMMENTS :

REVISION :

No.	Description	Date

8115-GREAT HOUSE PROJECT

TBD

INTERIOR ELEVATIONS 1

Project Number ###.##

Date Issue Date

Drawn By Author

Checked By Checker


A5.0

Scale 1/4" = 1'-0"




ARCHITECT'S SEAL :


DESIGN .efficiently

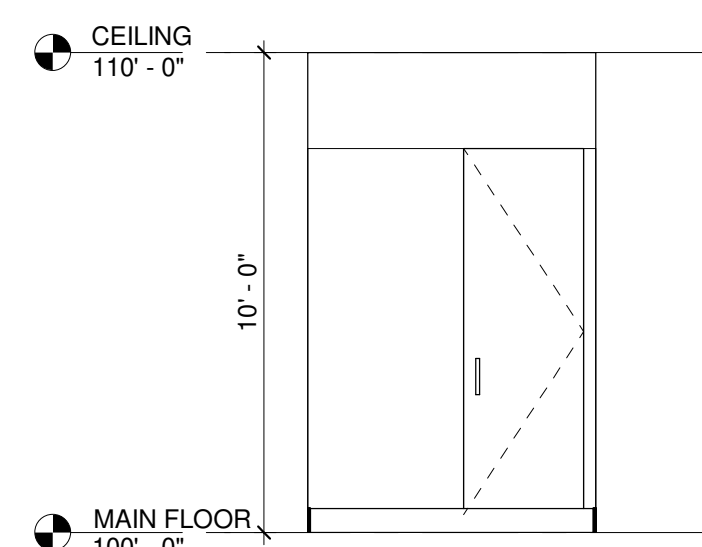


1 103-BATH-NORTH  
1/4" = 1'-0"

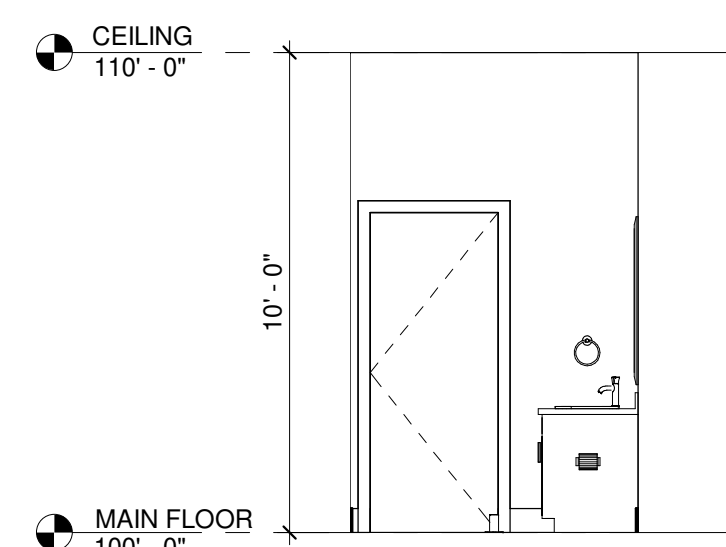


3 103-BATH-SOUTH  
1/4" = 1'-0"

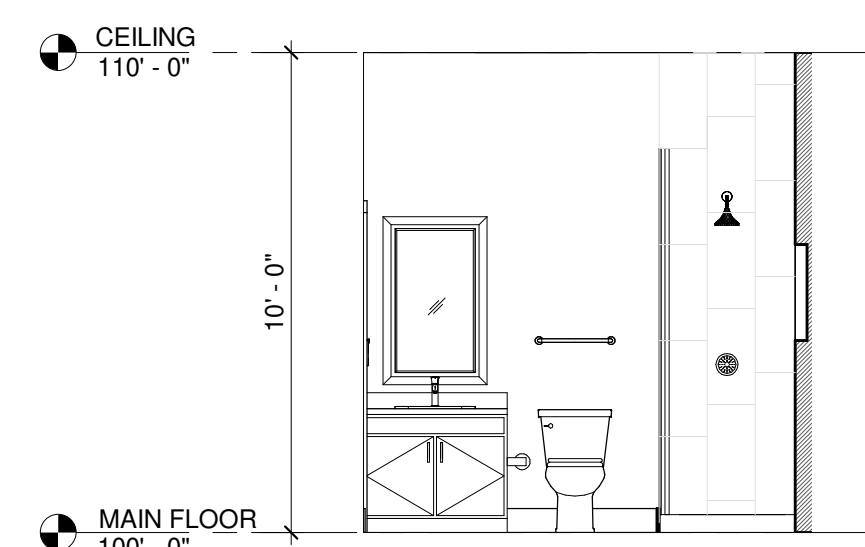


4 103-BATH-WEST  
1/4" = 1'-0"

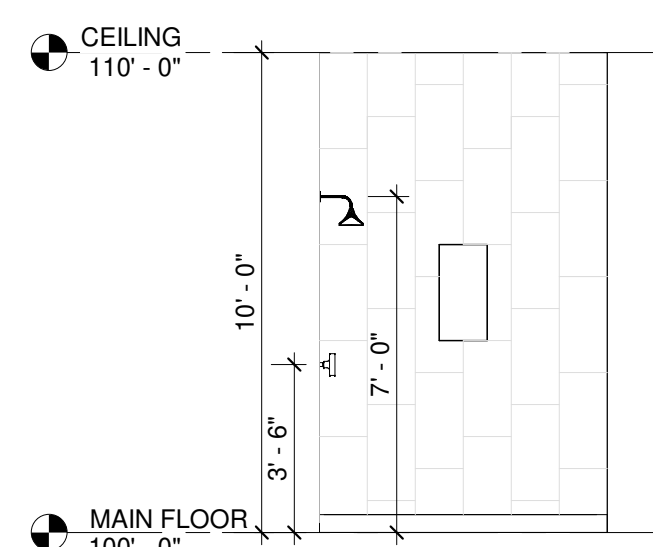


5 103-BATH SHOWER-NORTH  
1/4" = 1'-0"

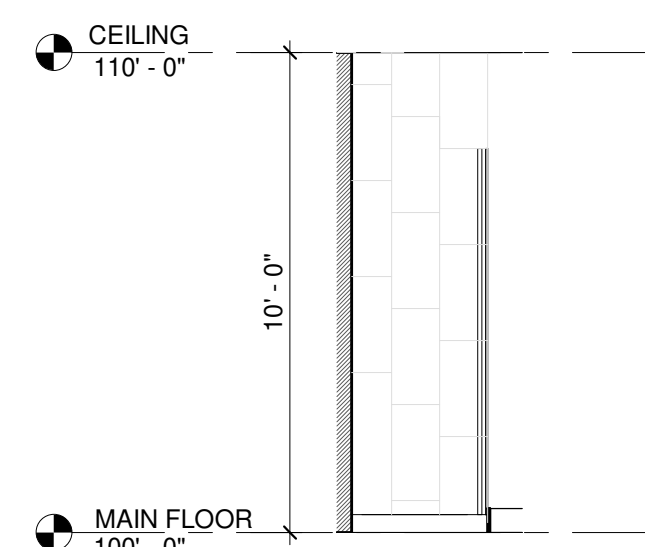


6 103-BATH SHOWER-EAST  
1/4" = 1'-0"

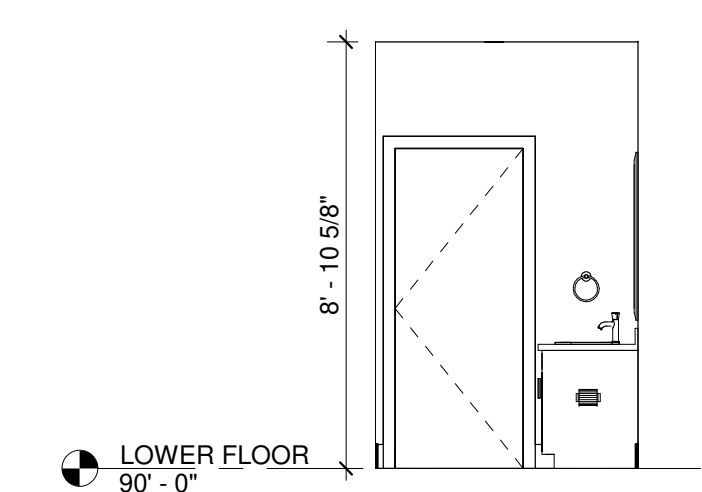


8 002-BATH-NORTH  
1/4" = 1'-0"

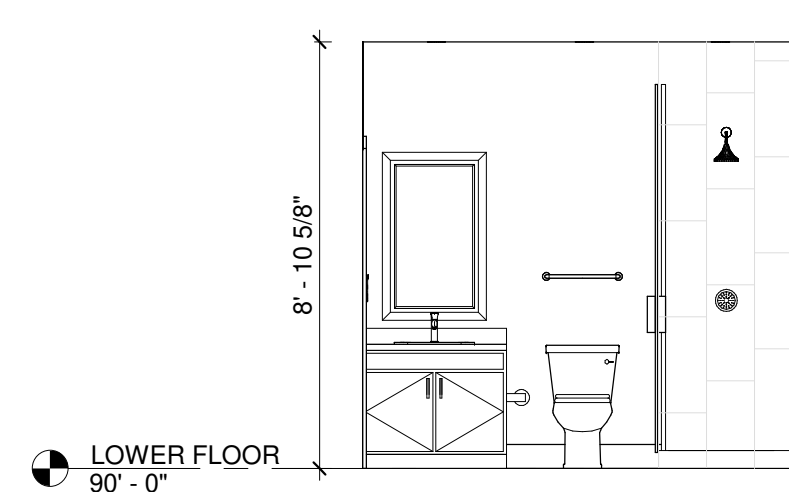


9 002-BATH-EAST  
1/4" = 1'-0"

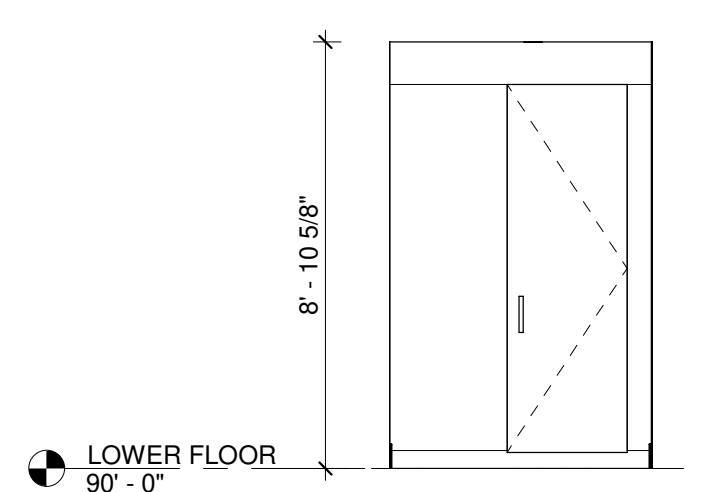


10 002-BATH-SOUTH  
1/4" = 1'-0"

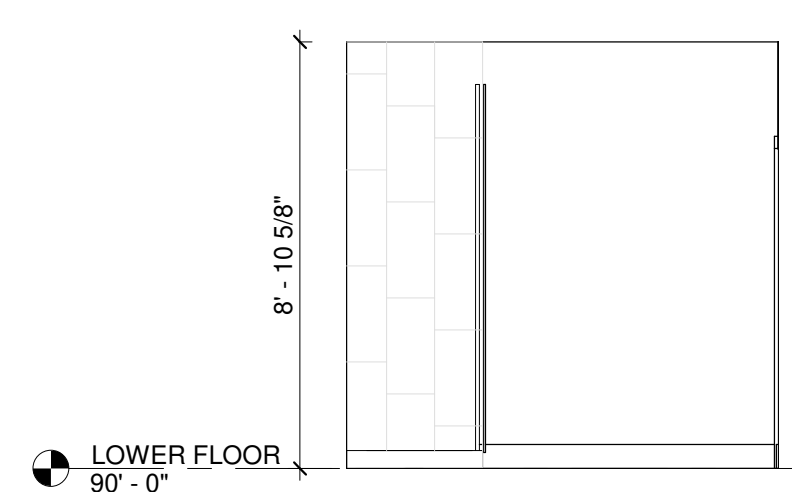


11 002-BATH-WEST  
1/4" = 1'-0"

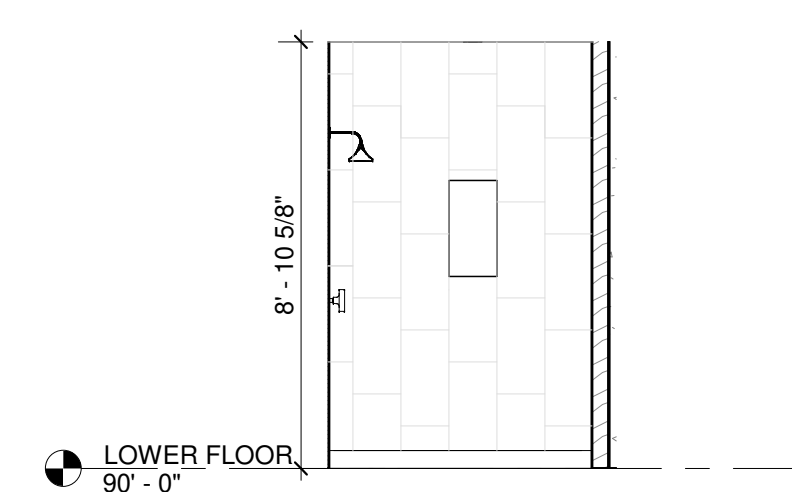


13 002-BATH SHOWER-SOUTH  
1/4" = 1'-0"

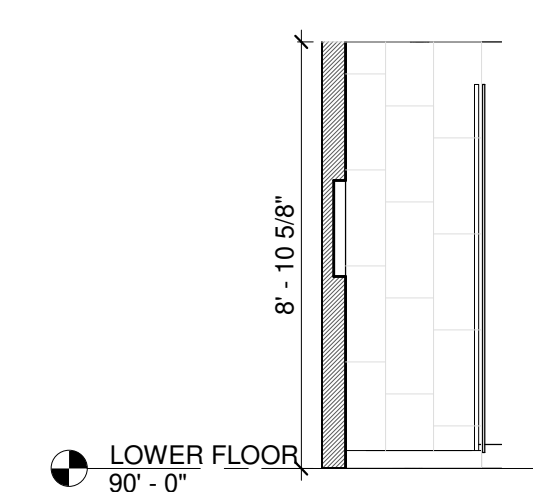


14 002-BATH SHOWER-WEST  
1/4" = 1'-0"

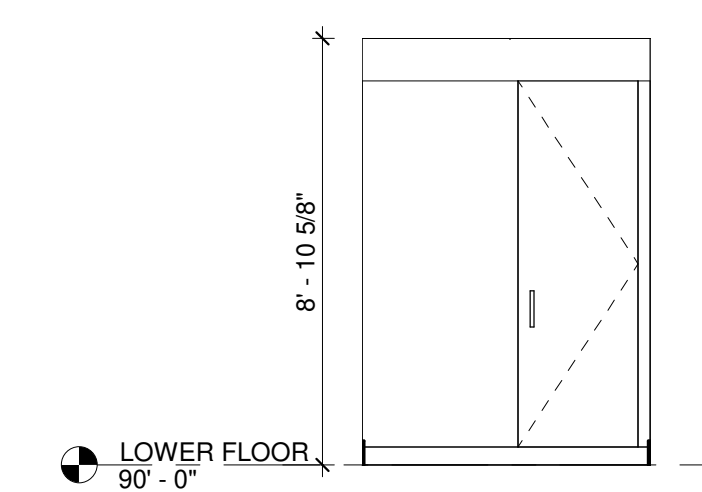


15 003-BATH-NORTH  
1/4" = 1'-0"

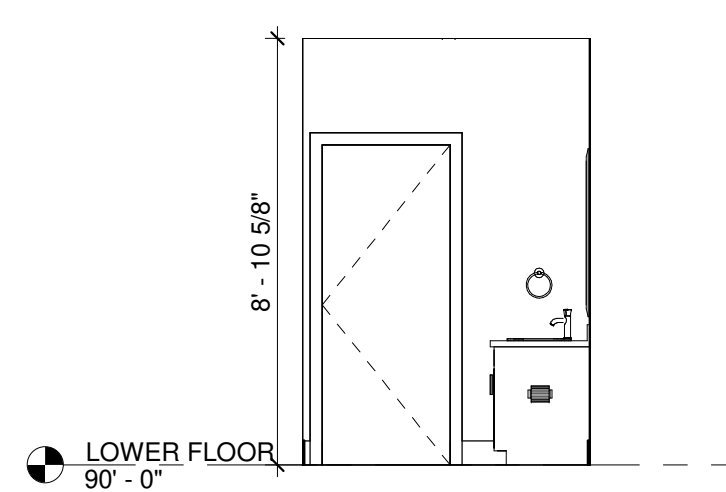


17 003-BATH-SOUTH  
1/4" = 1'-0"

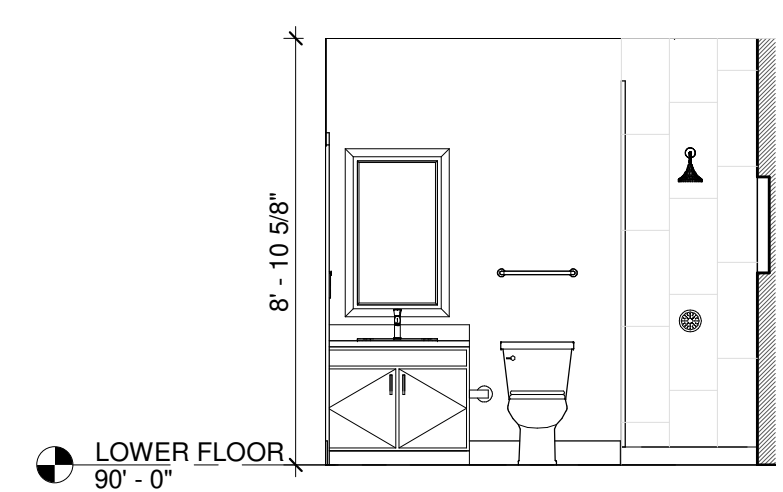


18 003-BATH-WEST  
1/4" = 1'-0"

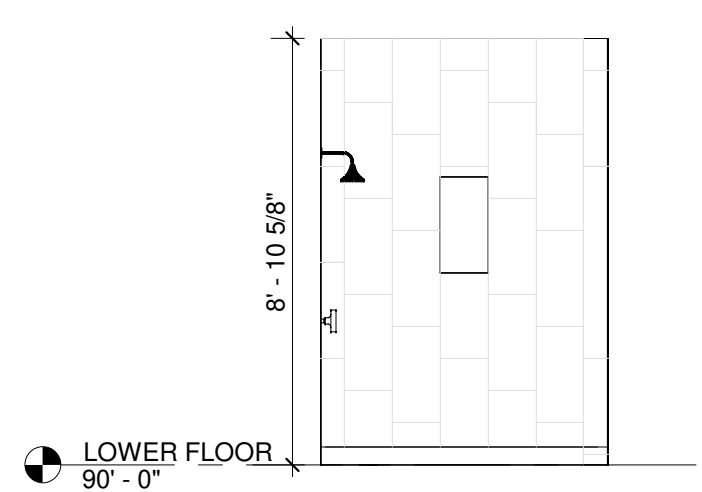

19 003-BATH SHOWER-NORTH  
1/4" = 1'-0"

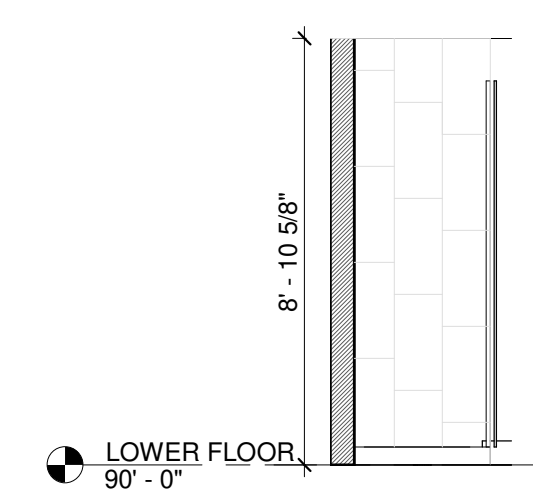

20 003-BATH SHOWER-EAST  
1/4" = 1'-0"

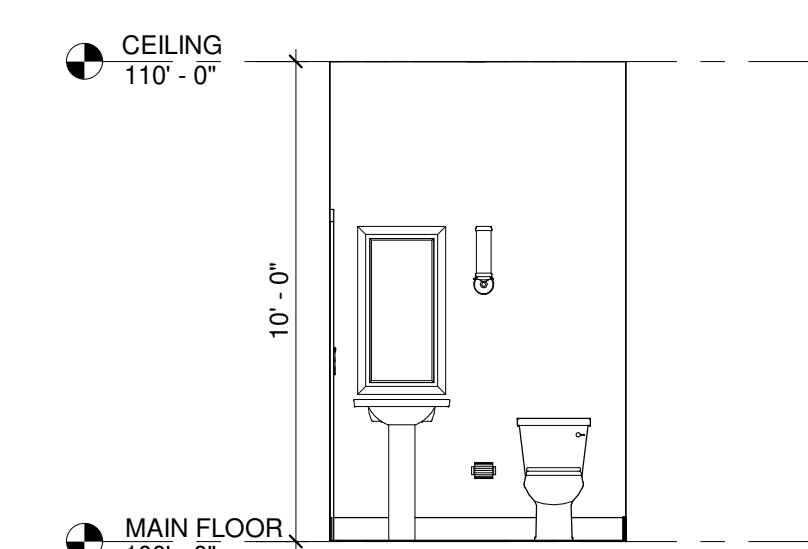

22 119-POWDER-NORTH  
1/4" = 1'-0"

CHECKED BY : Checker

DRAWN BY : Author

COMMENTS :

REVISION :

No.	Description	Date

8115-GREAT HOUSE  
PROJECT


TBD

INTERIOR ELEVATIONS 2

Project Number	###
Date	Issue Date
Drawn By	Author
Checked By	Checker

A5.1

Scale 1/4" = 1'-0"

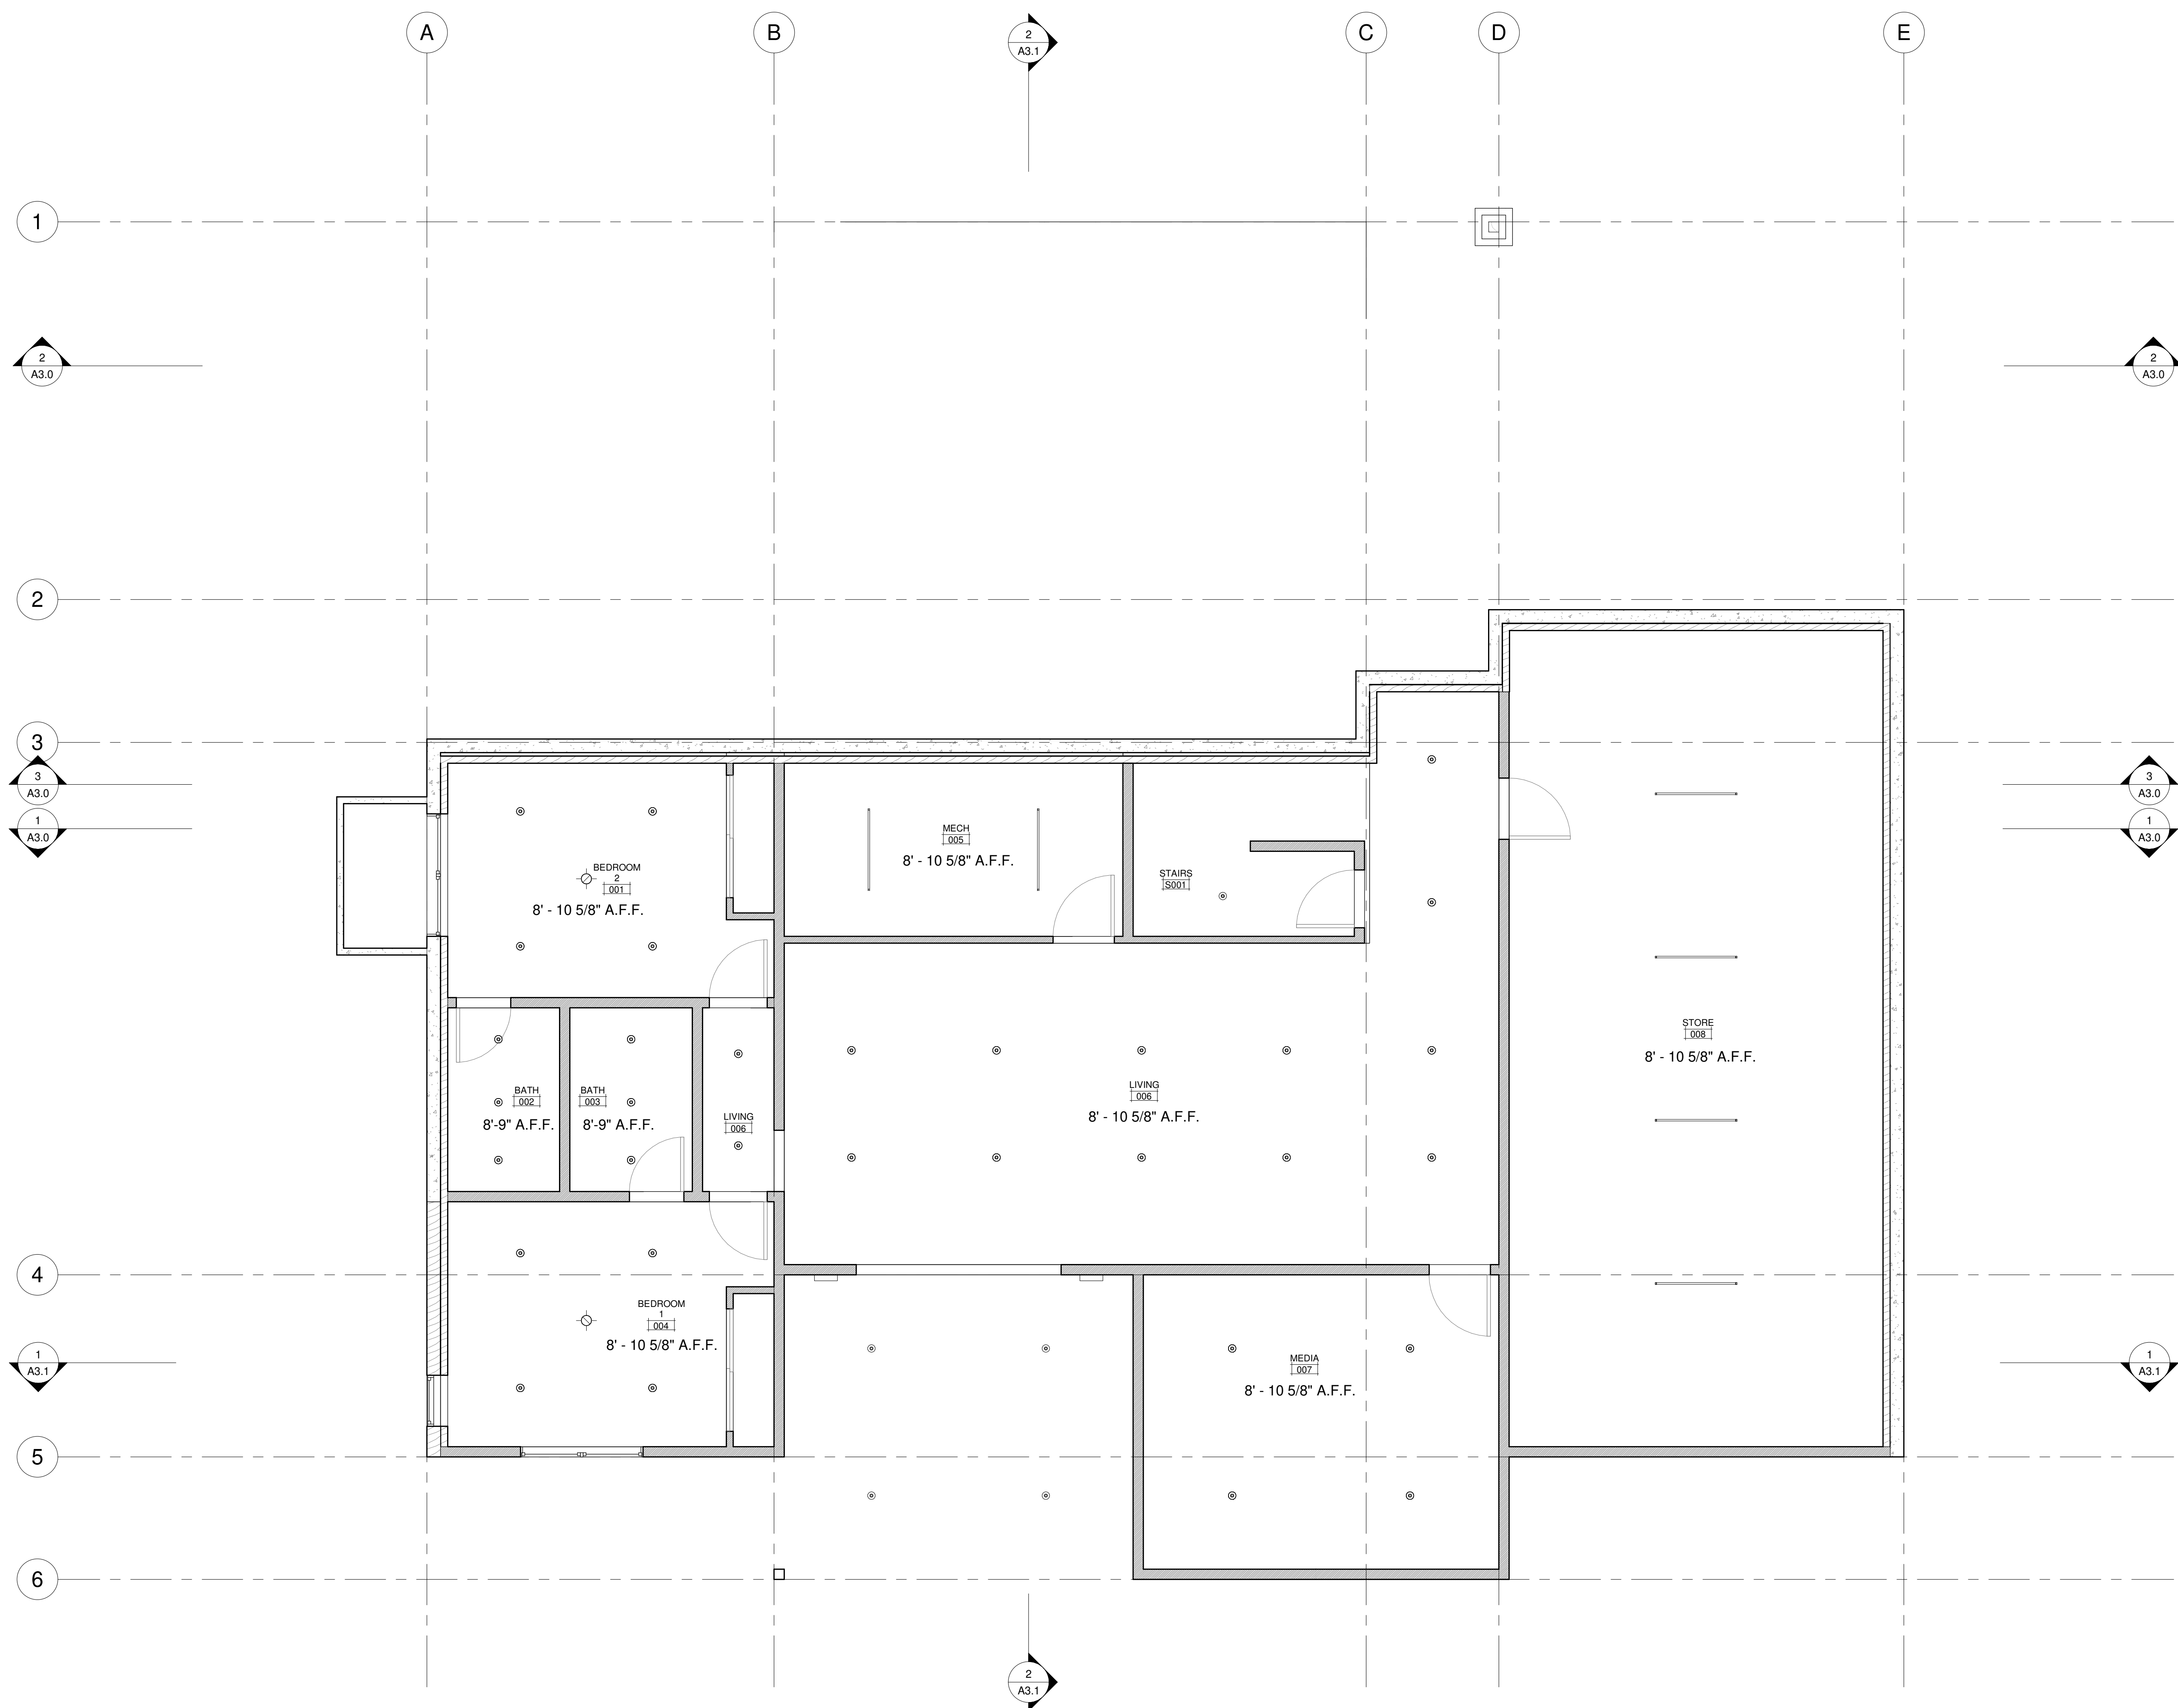

1 LOWER LEVEL - REFLECTED CEILING PLAN  
1/4" = 1'-0"

ARCHITECT'S SEAL :



CHECKED BY : Checker

DRAWN BY : Author

COMMENTS :

REVISION :

No.	Description	Date

8115-GREAT HOUSE PROJECT

TBD

LOWER LEVEL - REFLECTED CEILING PLAN

Project Number      ##.##

Date      Issue Date


Drawn By      Author

Checked By      Checker

**A6.0**

Scale      1/4" = 1'-0"



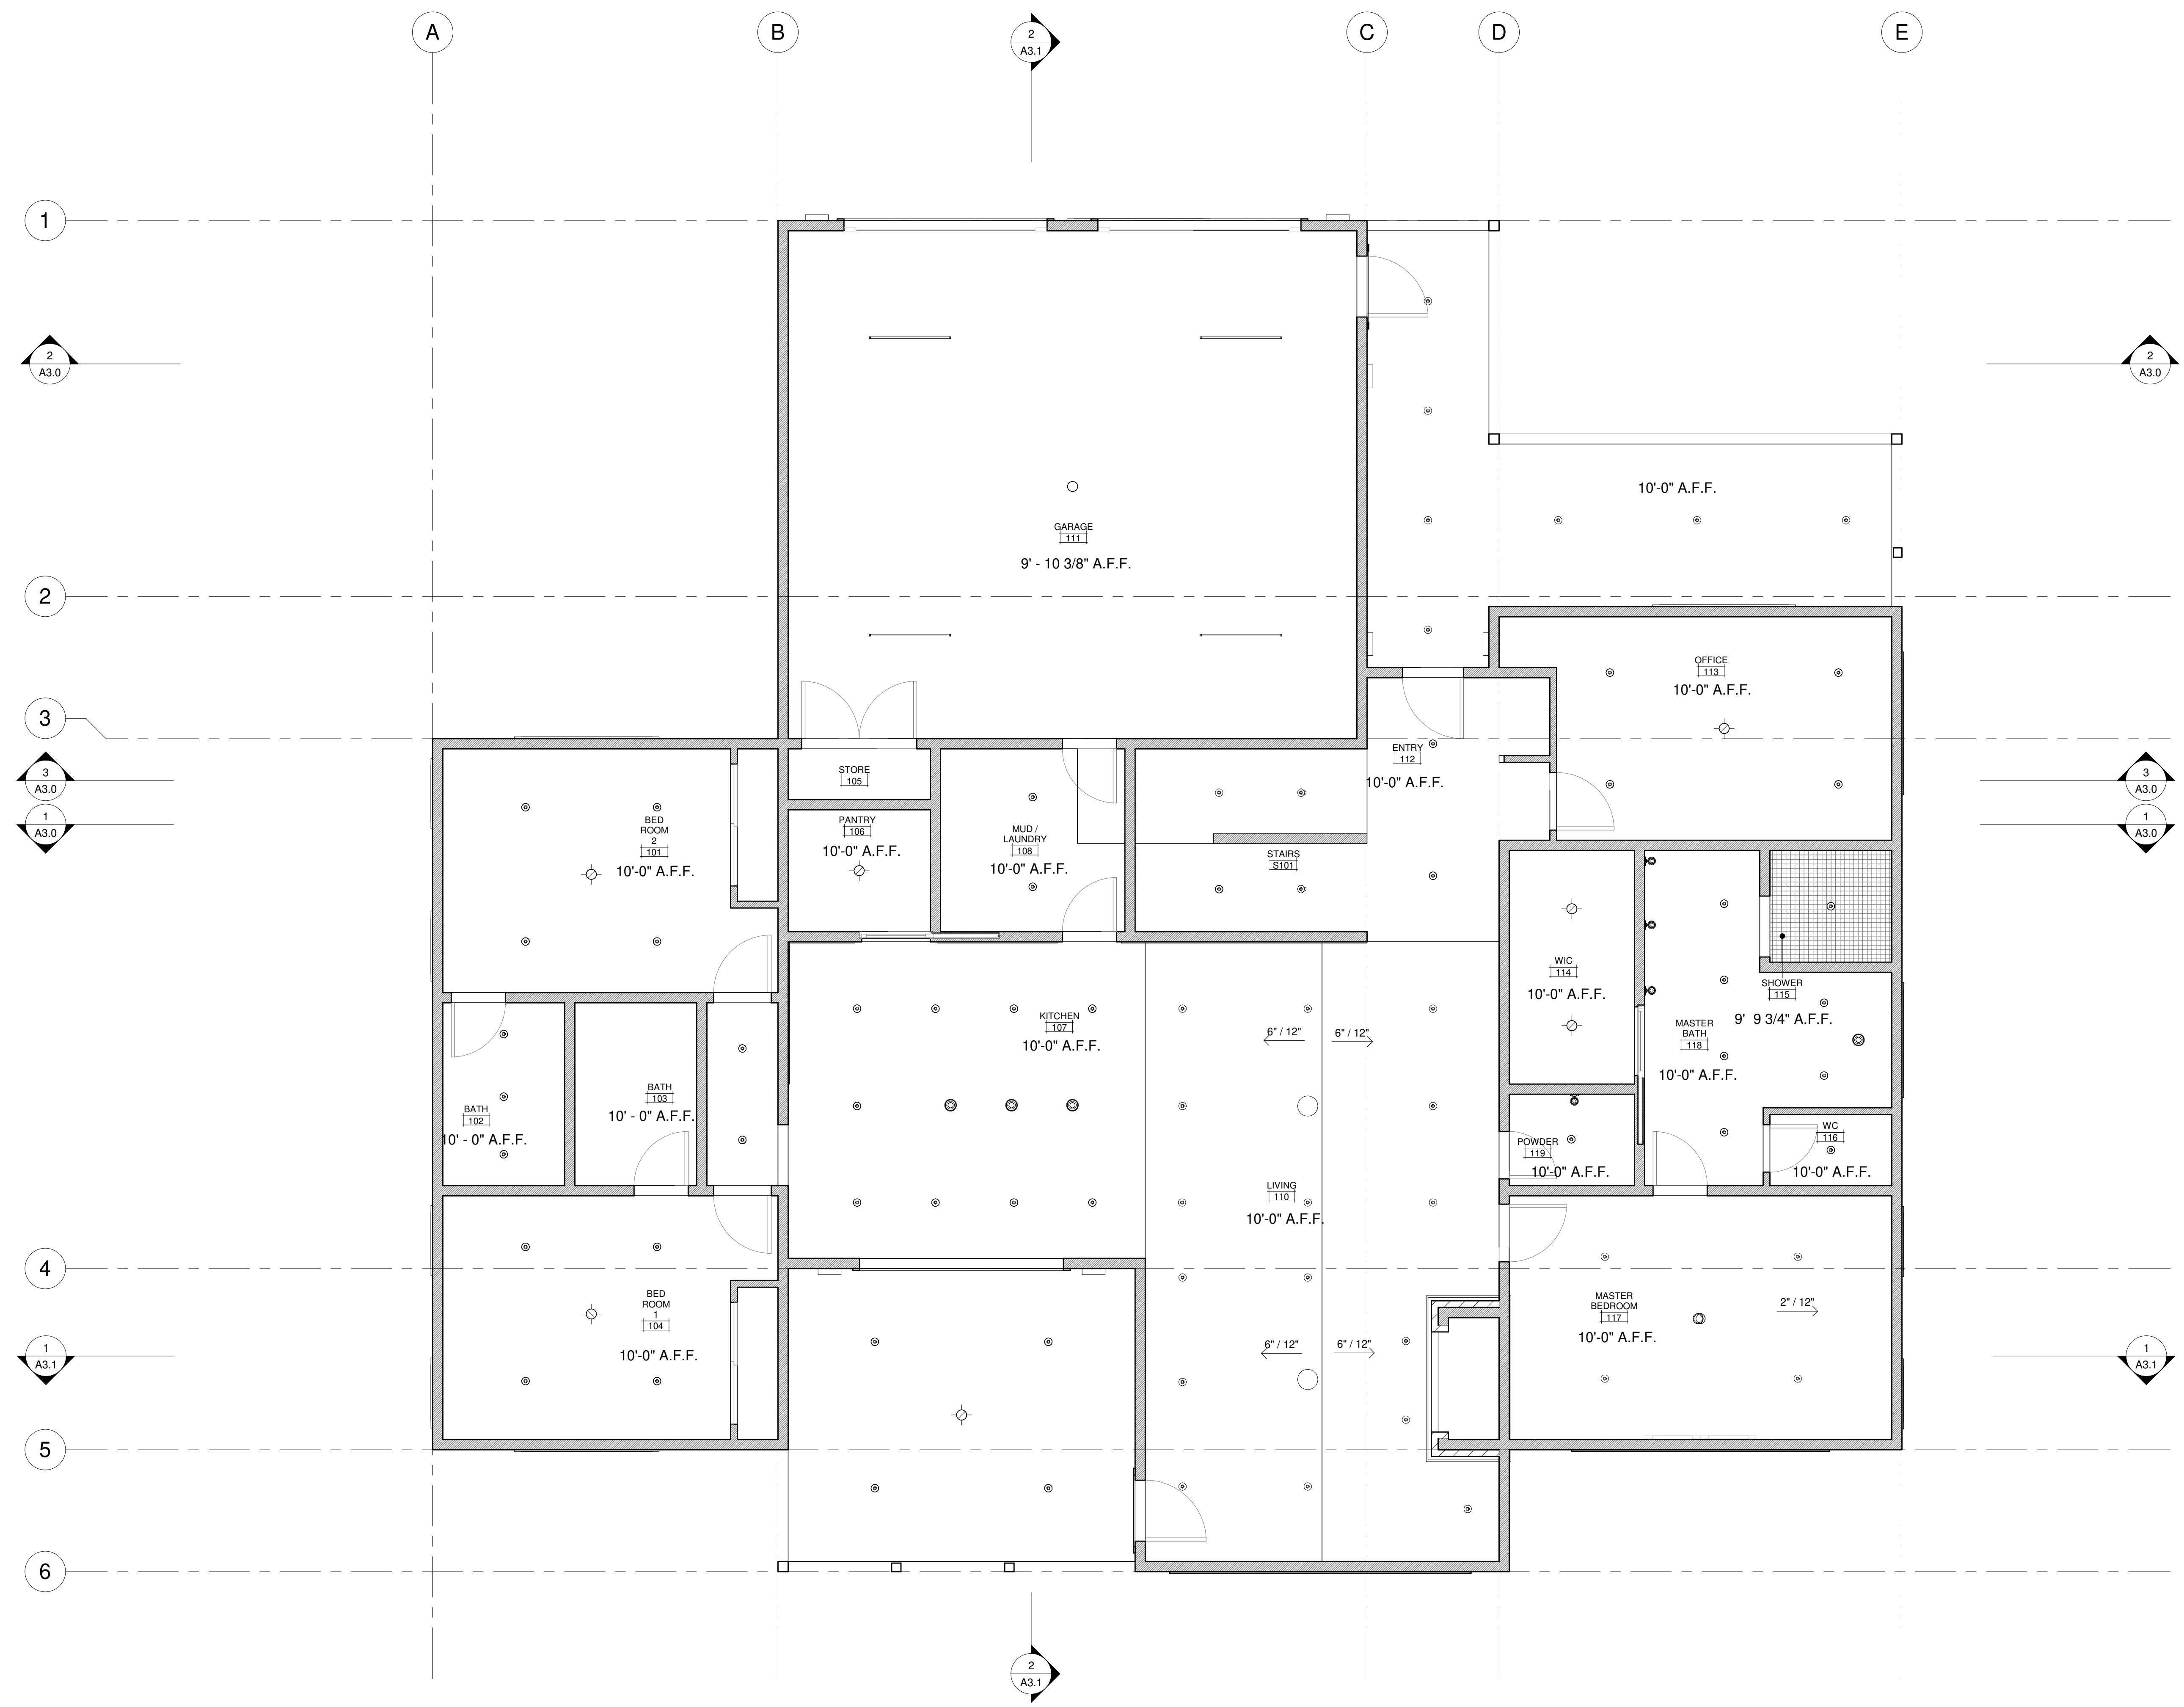

① MAIN LEVEL - REFLECTED CEILING PLAN  
1/4" = 1'-0"

ARCHITECT'S SEAL :



CHECKED BY : Checker

DRAWN BY : Author

COMMENTS :

---



---



---



---

REVISION :

No.	Description	Date

8115-GREAT HOUSE PROJECT

TBD

MAIN LEVEL - REFLECTED CEILING PLAN

Project Number	###
Date	Issue Date
Drawn By	Author
Checked By	Checker

**A6.1**

Scale 1/4" = 1'-0"

ARCHITECT'S SEAL :

DESIGN **.efficiently**

CHECKED BY : Checker

DRAWN BY : Author

COMMENTS :

REVISION :

No.	Description	Date

8115-GREAT HOUSE  
PROJECT

TBD

BONUS ROOM REFLECTED CEILING  
PLAN

Project Number **##.##**


Date **Issue Date**

Drawn By **Author**

Checked By **Checker**


**A6.2**

Scale **1/4" = 1'-0"**

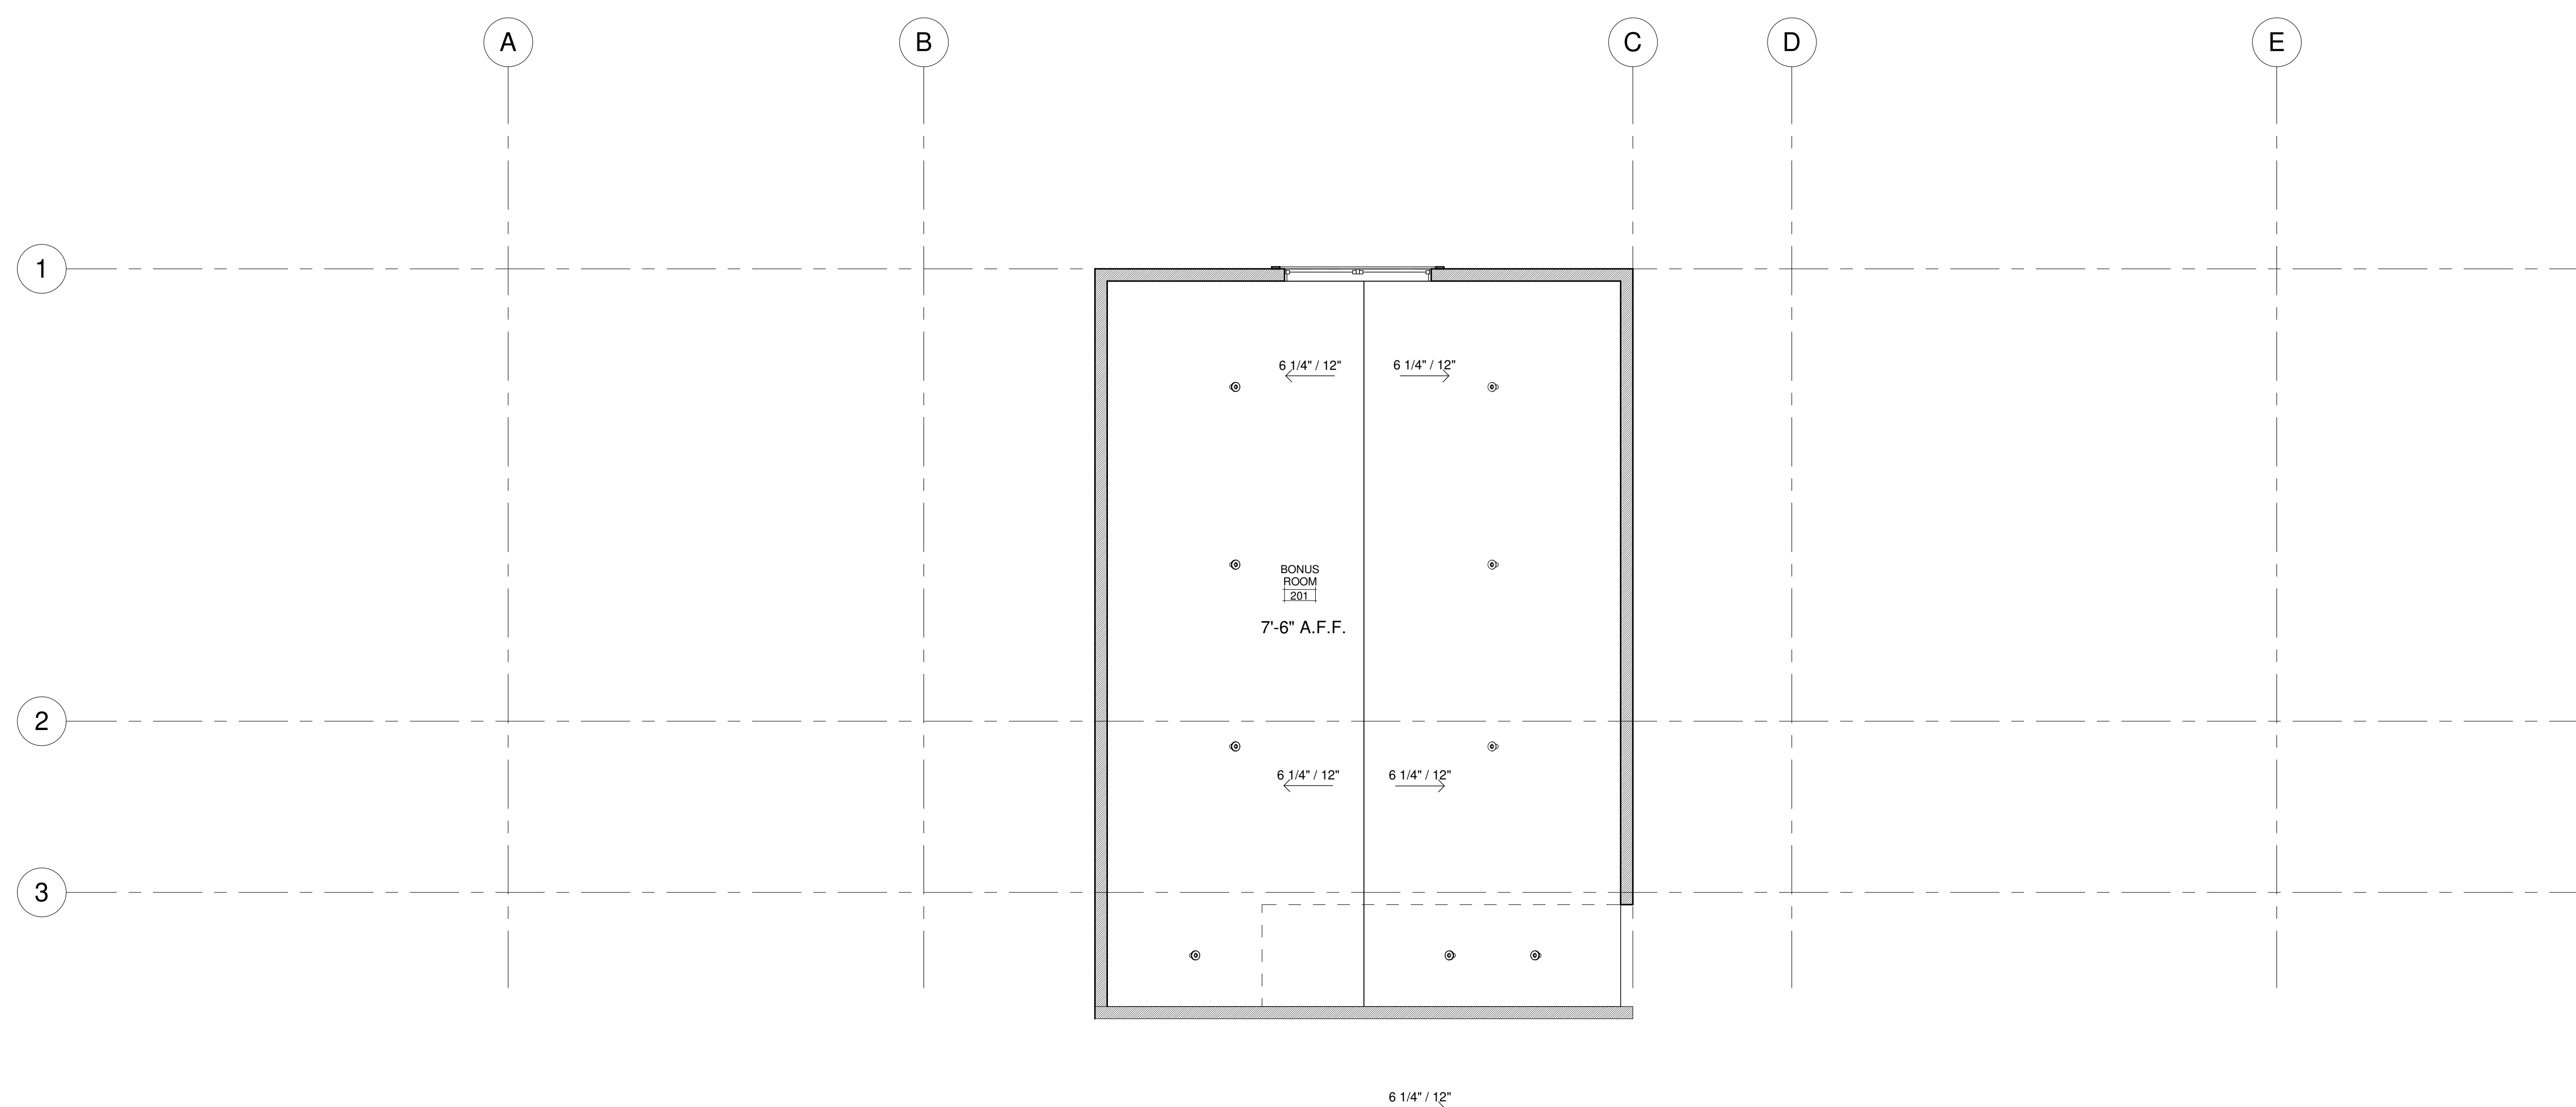

BONUS ROOM REFLECTED CEILING  
PLAN  
1/4" = 1'-0"



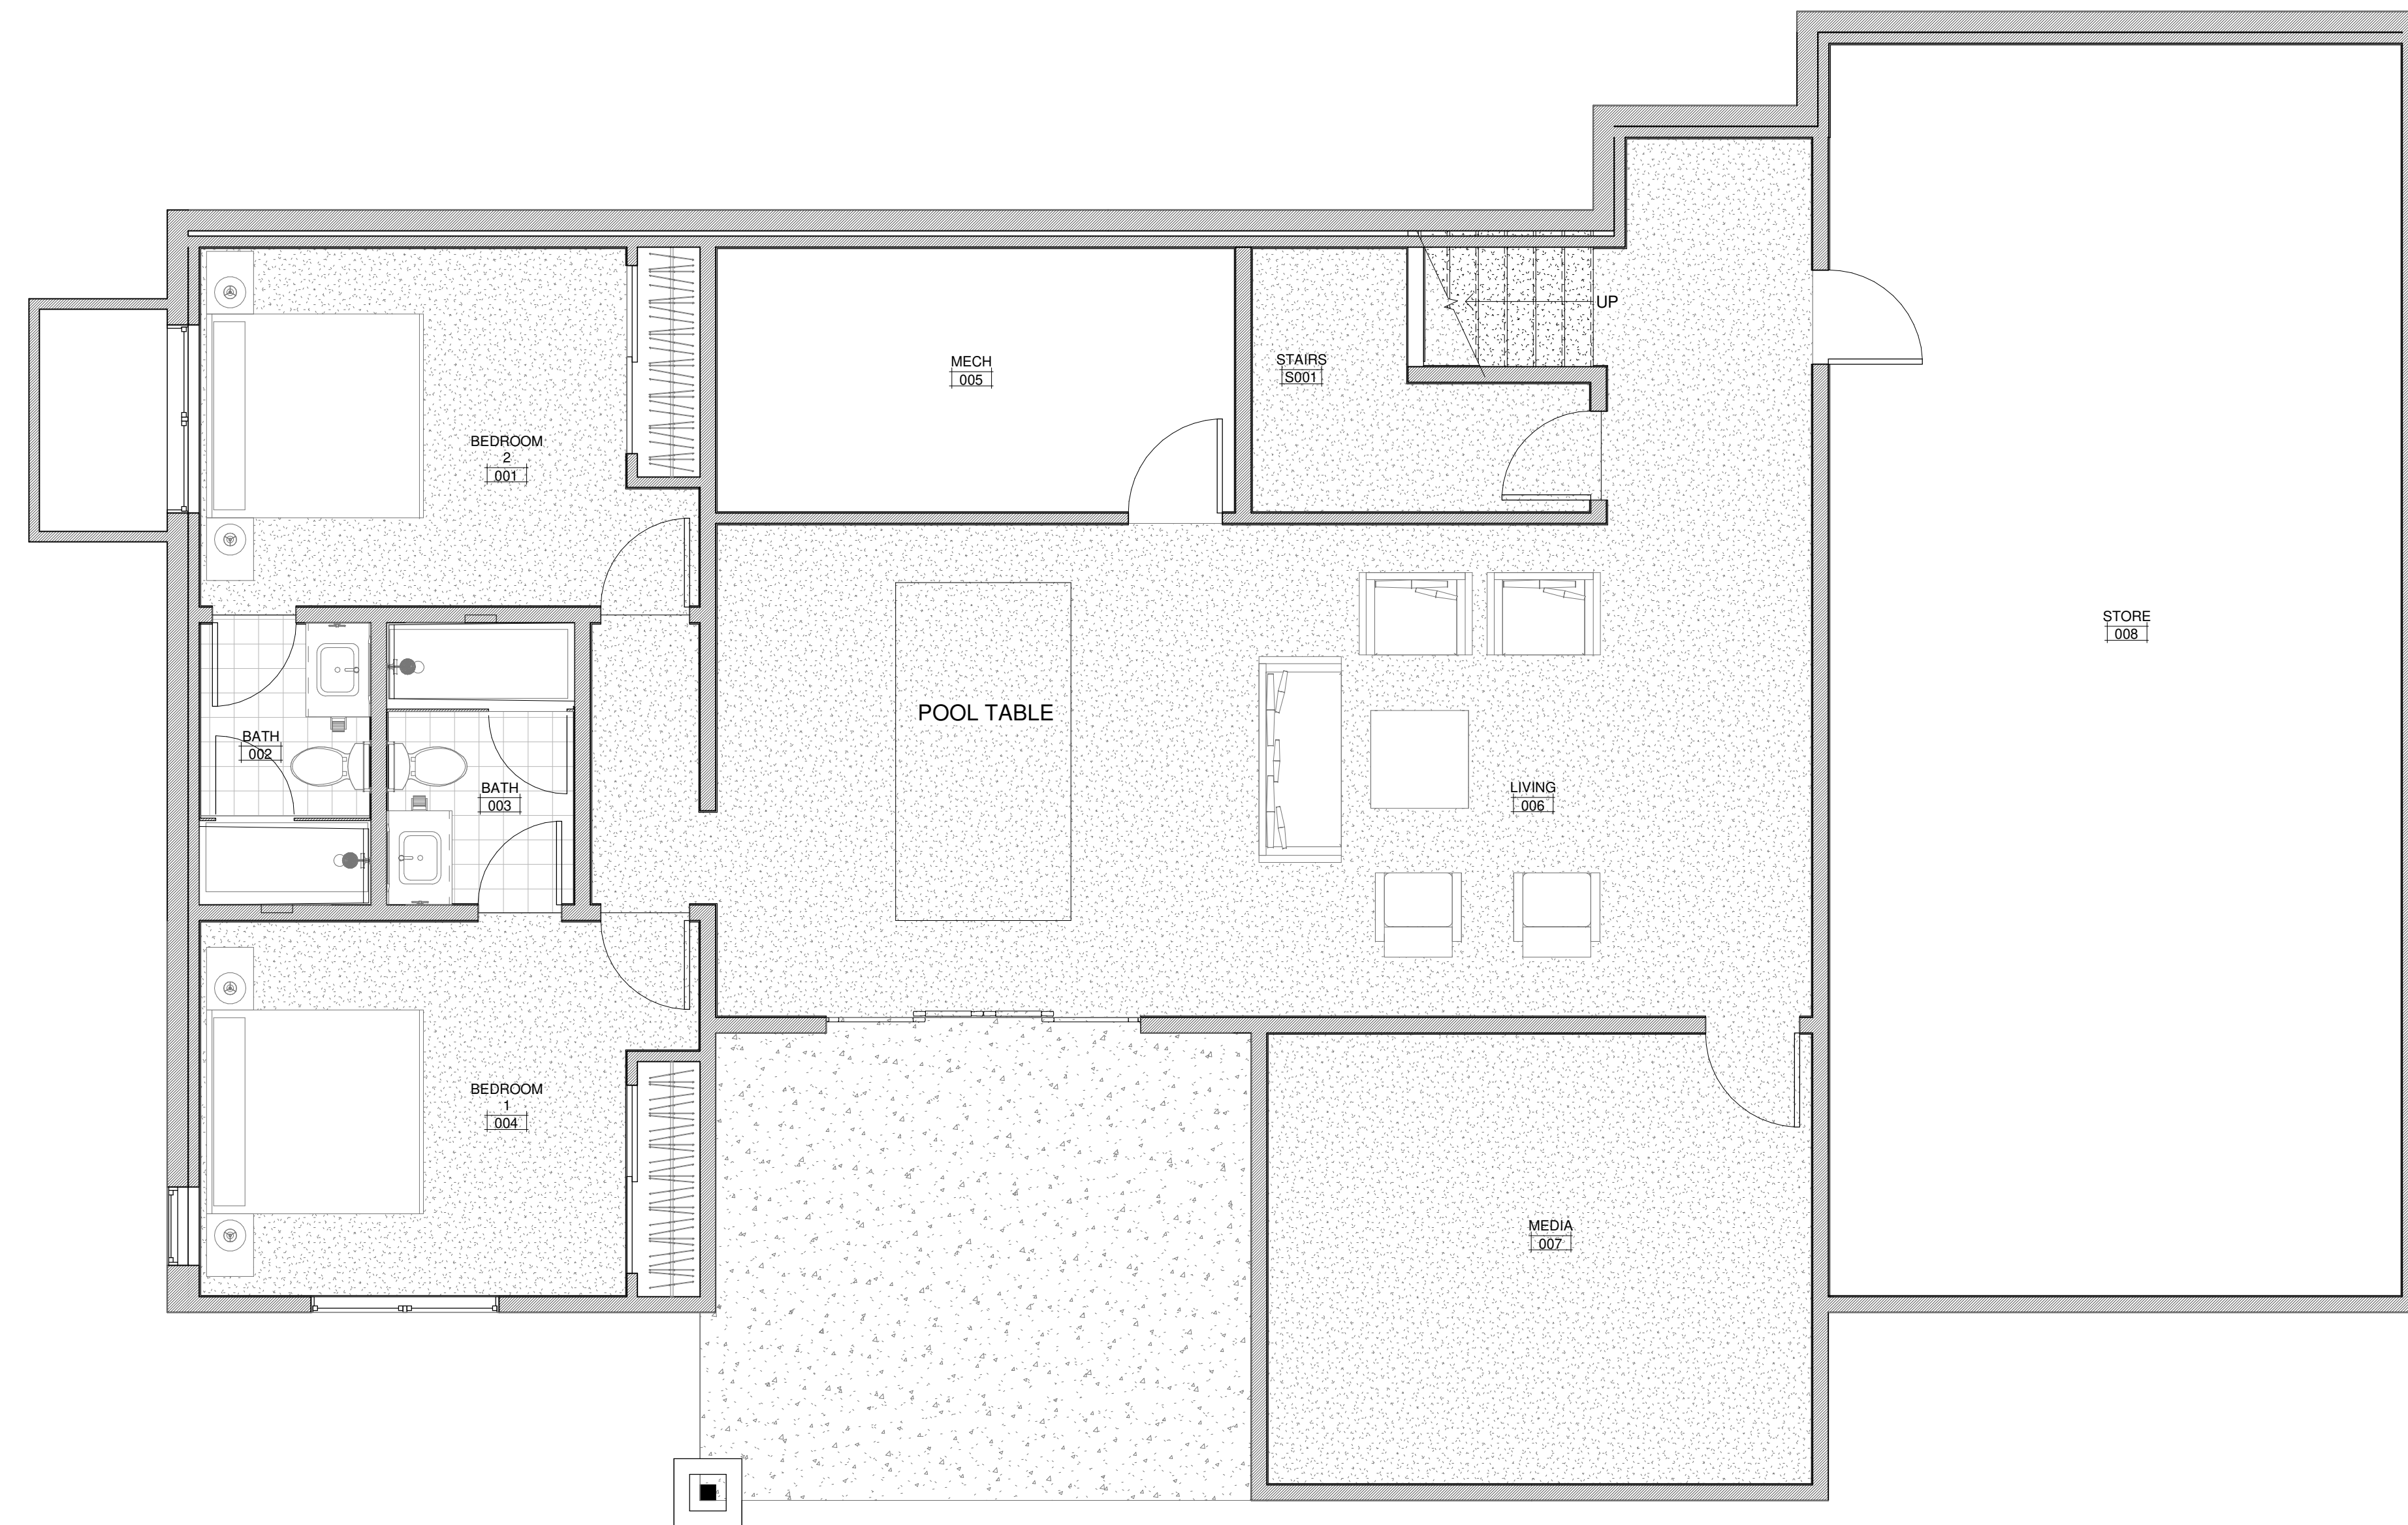

① FINISH PLAN LOWER FLOOR  
1/4" = 1'-0"

ARCHITECT'S SEAL :

**DESIGN** .efficiently

CHECKED BY : Checker

DRAWN BY : Author

COMMENTS :

\_\_\_\_\_

\_\_\_\_\_

\_\_\_\_\_

REVISION :

No.	Description	Date

**8115-GREAT HOUSE  
PROJECT**

TBD

FINISH PLAN LOWER FLOOR

Project Number ###

Date Issue Date

Drawn By Author

Checked By Checker

**A7.0**

Scale 1/4" = 1'-0"

ARCHITECT'S SEAL :

DESIGN .efficiently



CHECKED BY : Checker

DRAWN BY : Author

COMMENTS :

REVISION :

No.	Description	Date

8115-GREAT HOUSE PROJECT

TBD

FINISH PLAN MAIN FLOOR

1 FINISH PLAN MAIN FLOOR  
1/4" = 1'-0"

Project Number	###.##
Date	Issue Date
Drawn By	Author
Checked By	Checker

A7.1

Scale	1/4" = 1'-0"
-------	--------------

ARCHITECT'S SEAL :

DESIGN .efficiently


CHECKED BY : Checker

DRAWN BY : Author

COMMENTS :

REVISION :

No.	Description	Date

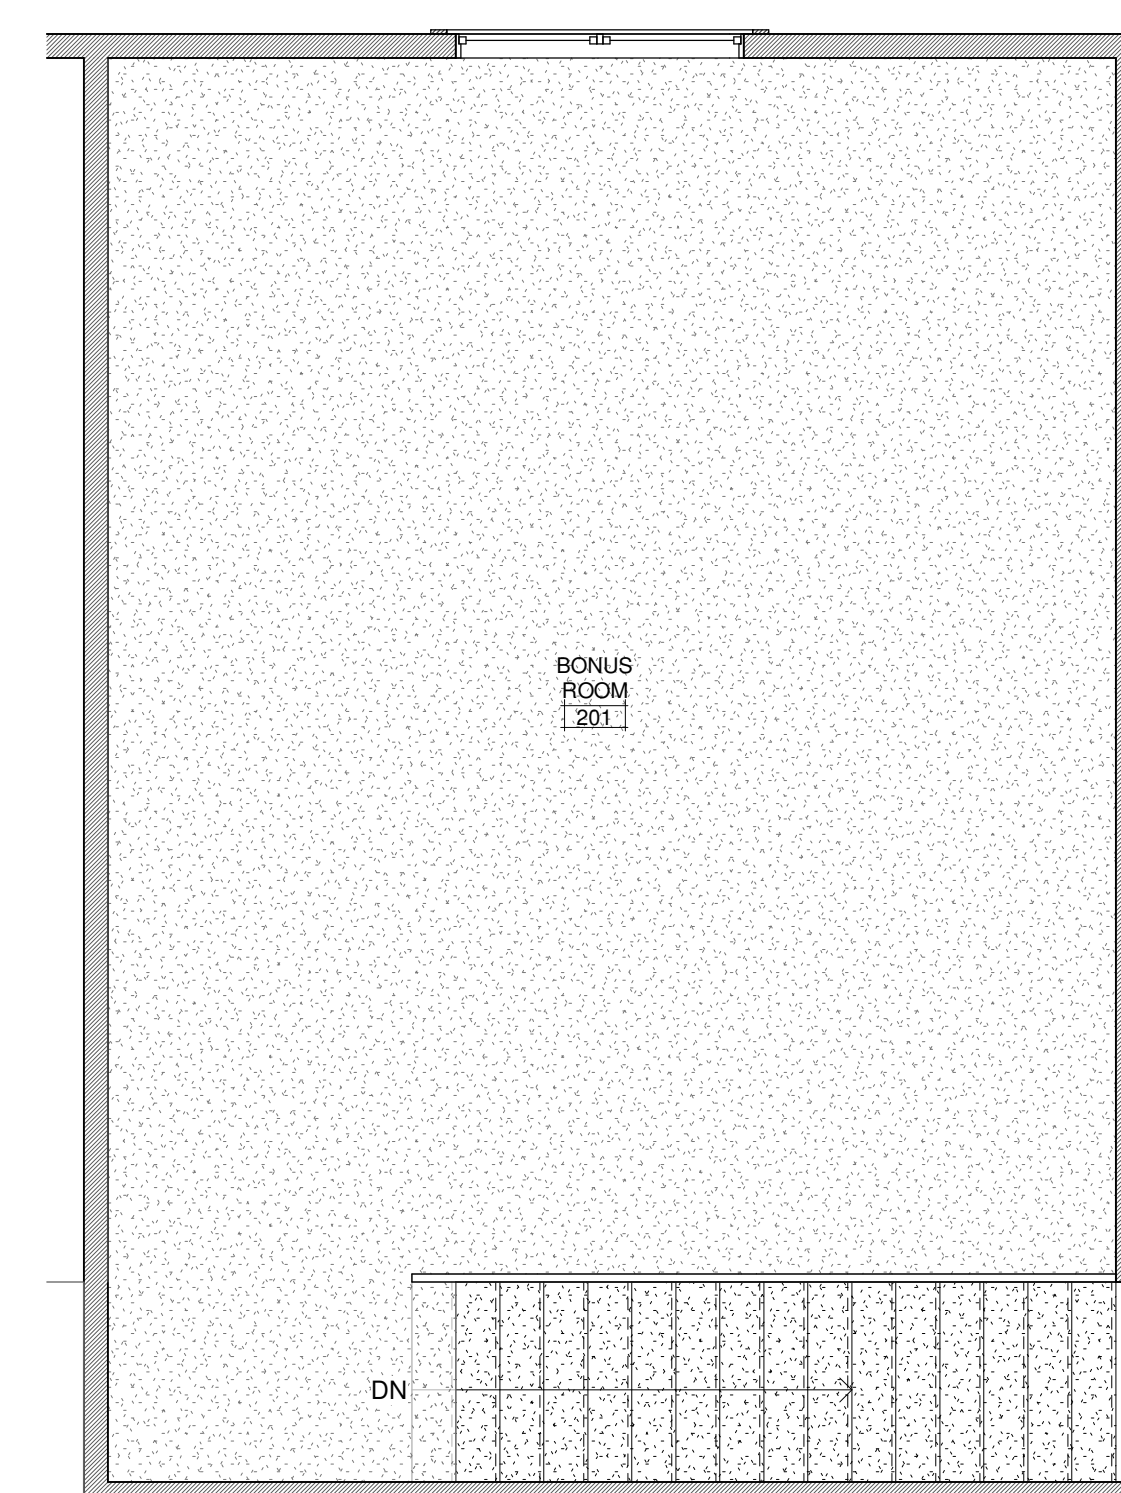

1 FINISH PLAN BONUS ROOM  
1/4" = 1'-0"

8115-GREAT HOUSE PROJECT

TBD


FINISH PLAN BONUS ROOM

Project Number	##.##
Date	Issue Date
Drawn By	Author
Checked By	Checker

A7.2

Scale 1/4" = 1'-0"



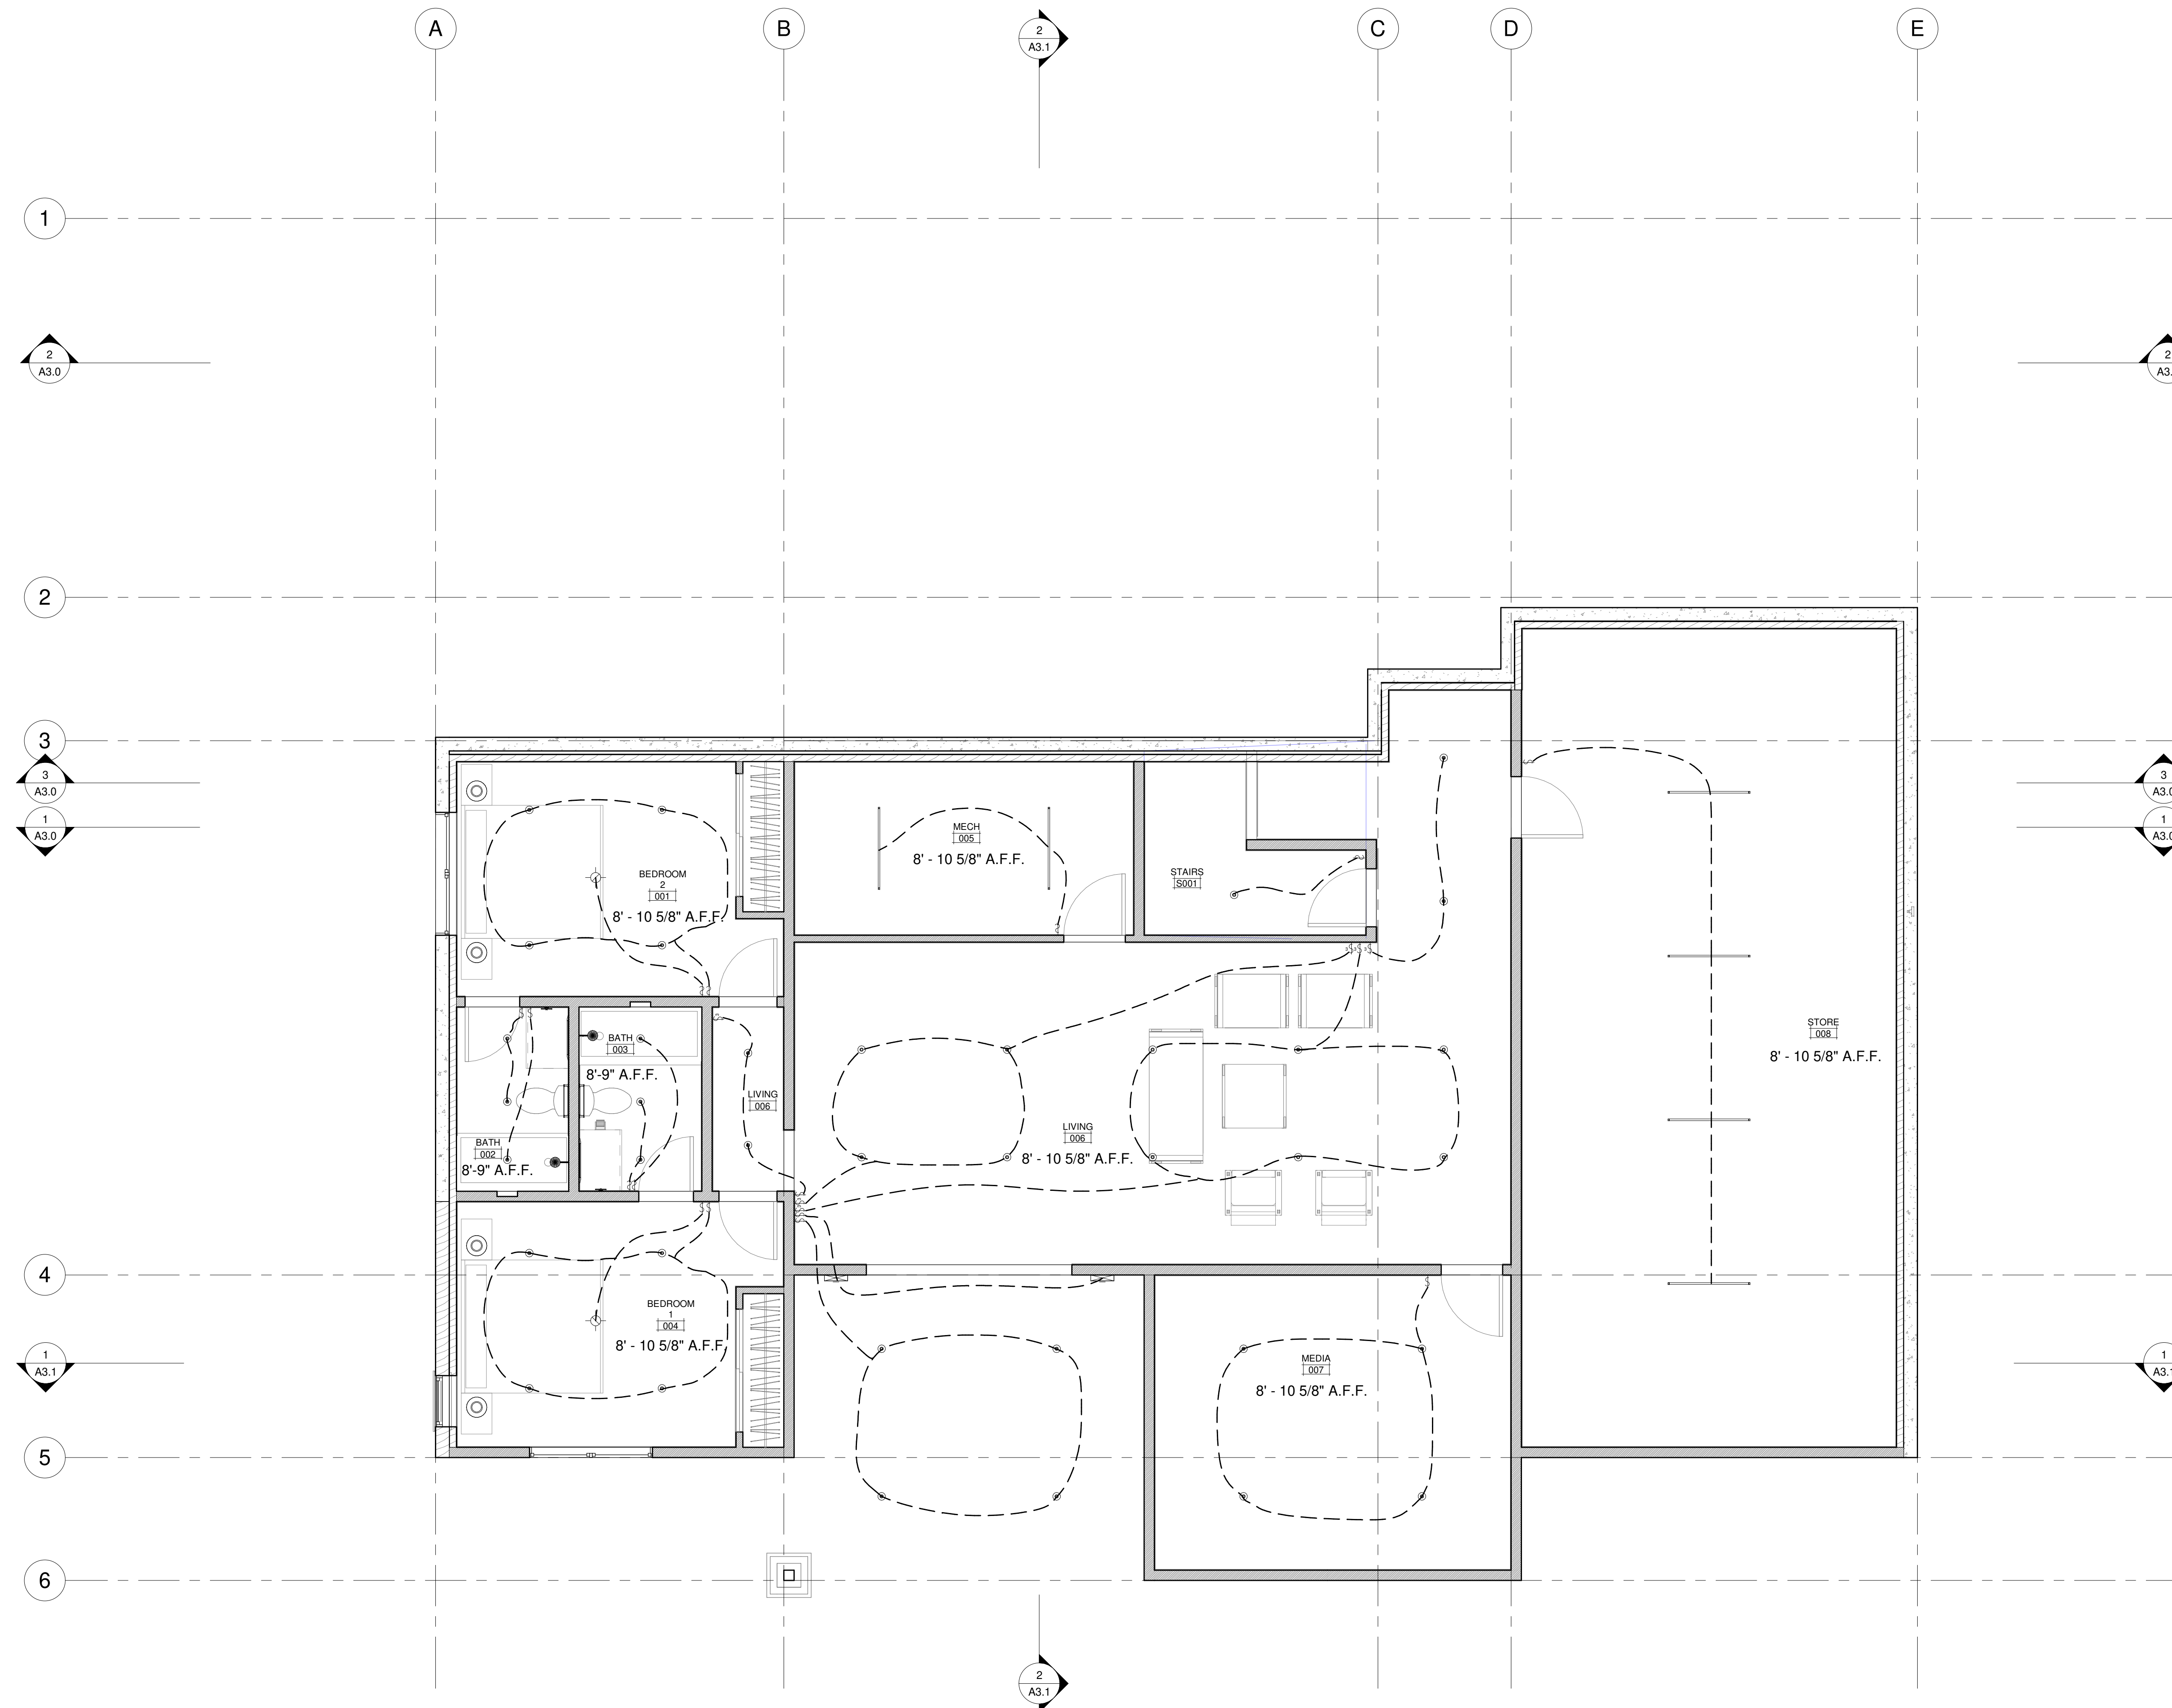

1 LOWER LEVEL - LIGHTING PLAN  
1/4" = 1'-0"

ARCHITECT'S SEAL :

DESIGN **efficiently**

CHECKED BY : Checker

DRAWN BY : Author

COMMENTS :

REVISION :

No.	Description	Date

8115-GREAT HOUSE  
PROJECT

TBD

LOWER LEVEL-LIGHTING PLAN

Project Number ###.##


Date Issue Date

Drawn By Author

Checked By Checker

**A8.0**

Scale 1/4" = 1'-0"

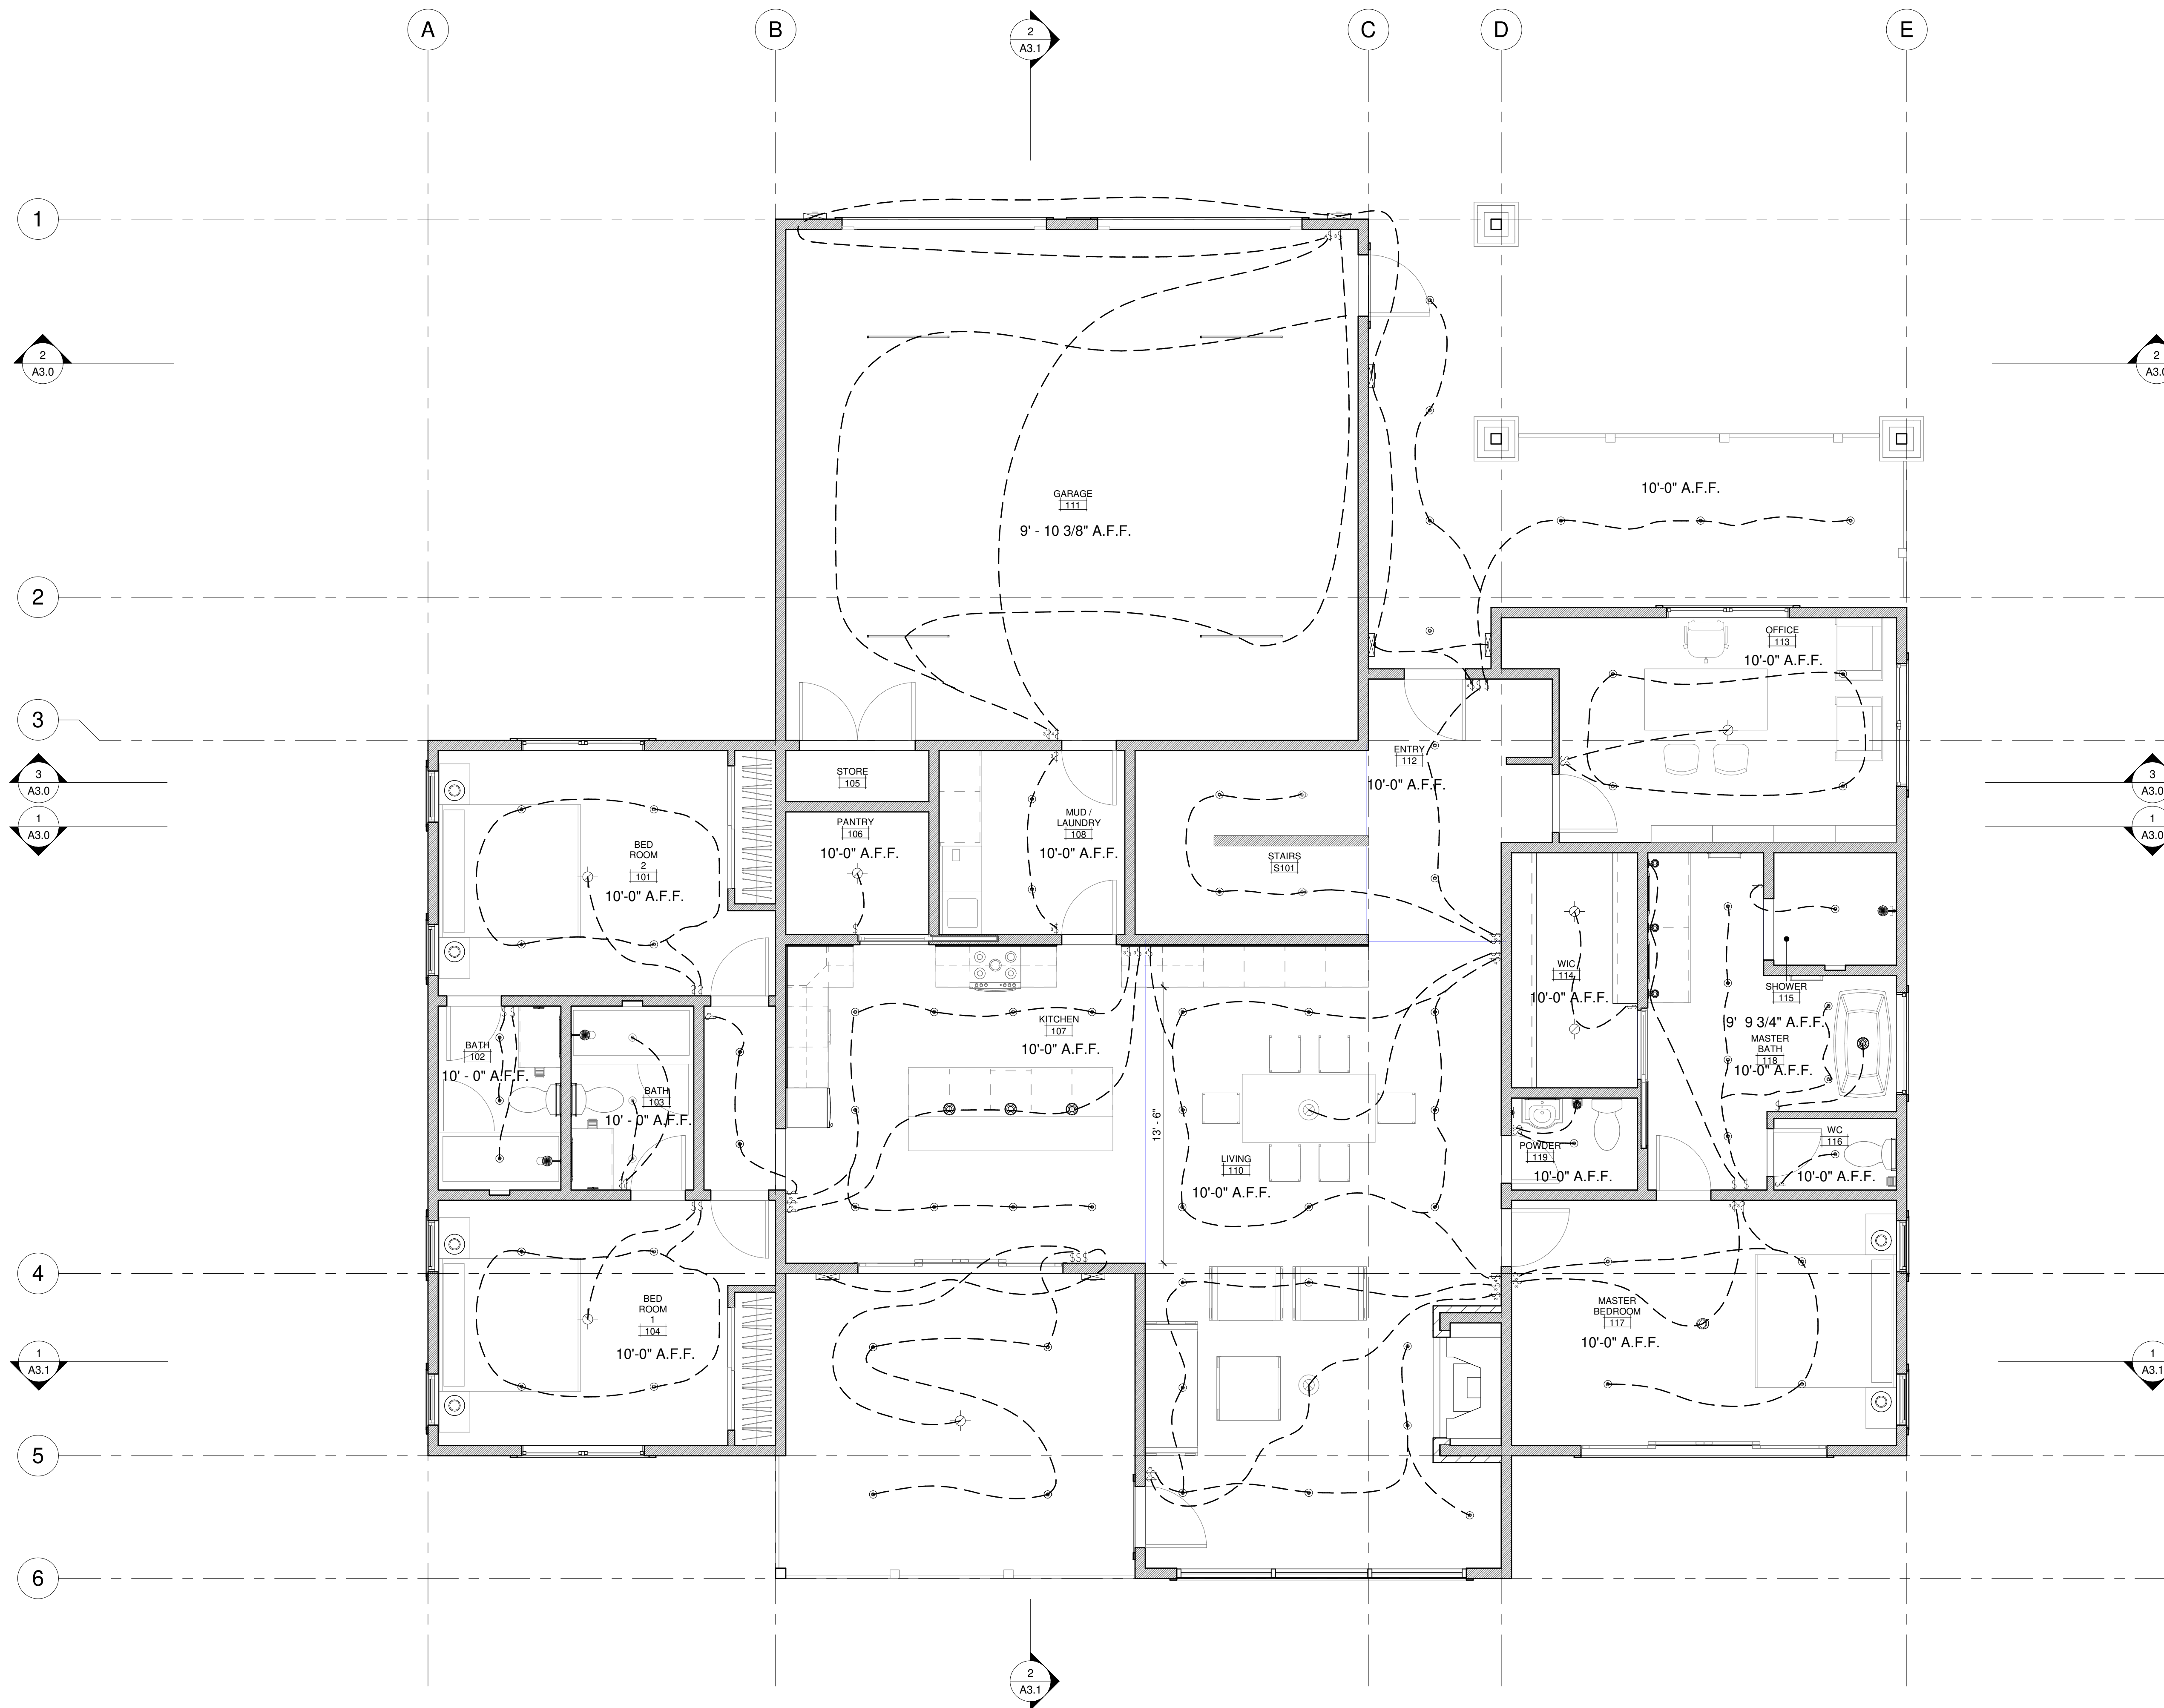

1 MAIN LEVEL-LIGHTING PLAN  
1/4" = 1'-0"

ARCHITECT'S SEAL :

DESIGN **.efficiently**

CHECKED BY : Checker

DRAWN BY : Author

COMMENTS :

REVISION :

No.	Description	Date

8115-GREAT HOUSE  
PROJECT

TBD

MAIN LEVEL-LIGHTING PLAN

Project Number	###.##
Date	Issue Date
Drawn By	Author
Checked By	Checker

**A8.1**

Scale	1/4" = 1'-0"
-------	--------------

ARCHITECT'S SEAL :

DESIGN **efficiently**

CHECKED BY : Checker

DRAWN BY : Author

COMMENTS :

REVISION :

No.	Description	Date

8115-GREAT HOUSE  
PROJECT


TBD

BONUS ROOM-LIGHTING PLAN

Project Number	###
Date	Issue Date
Drawn By	Author
Checked By	Checker

A8.2

Scale 1/4" = 1'-0"

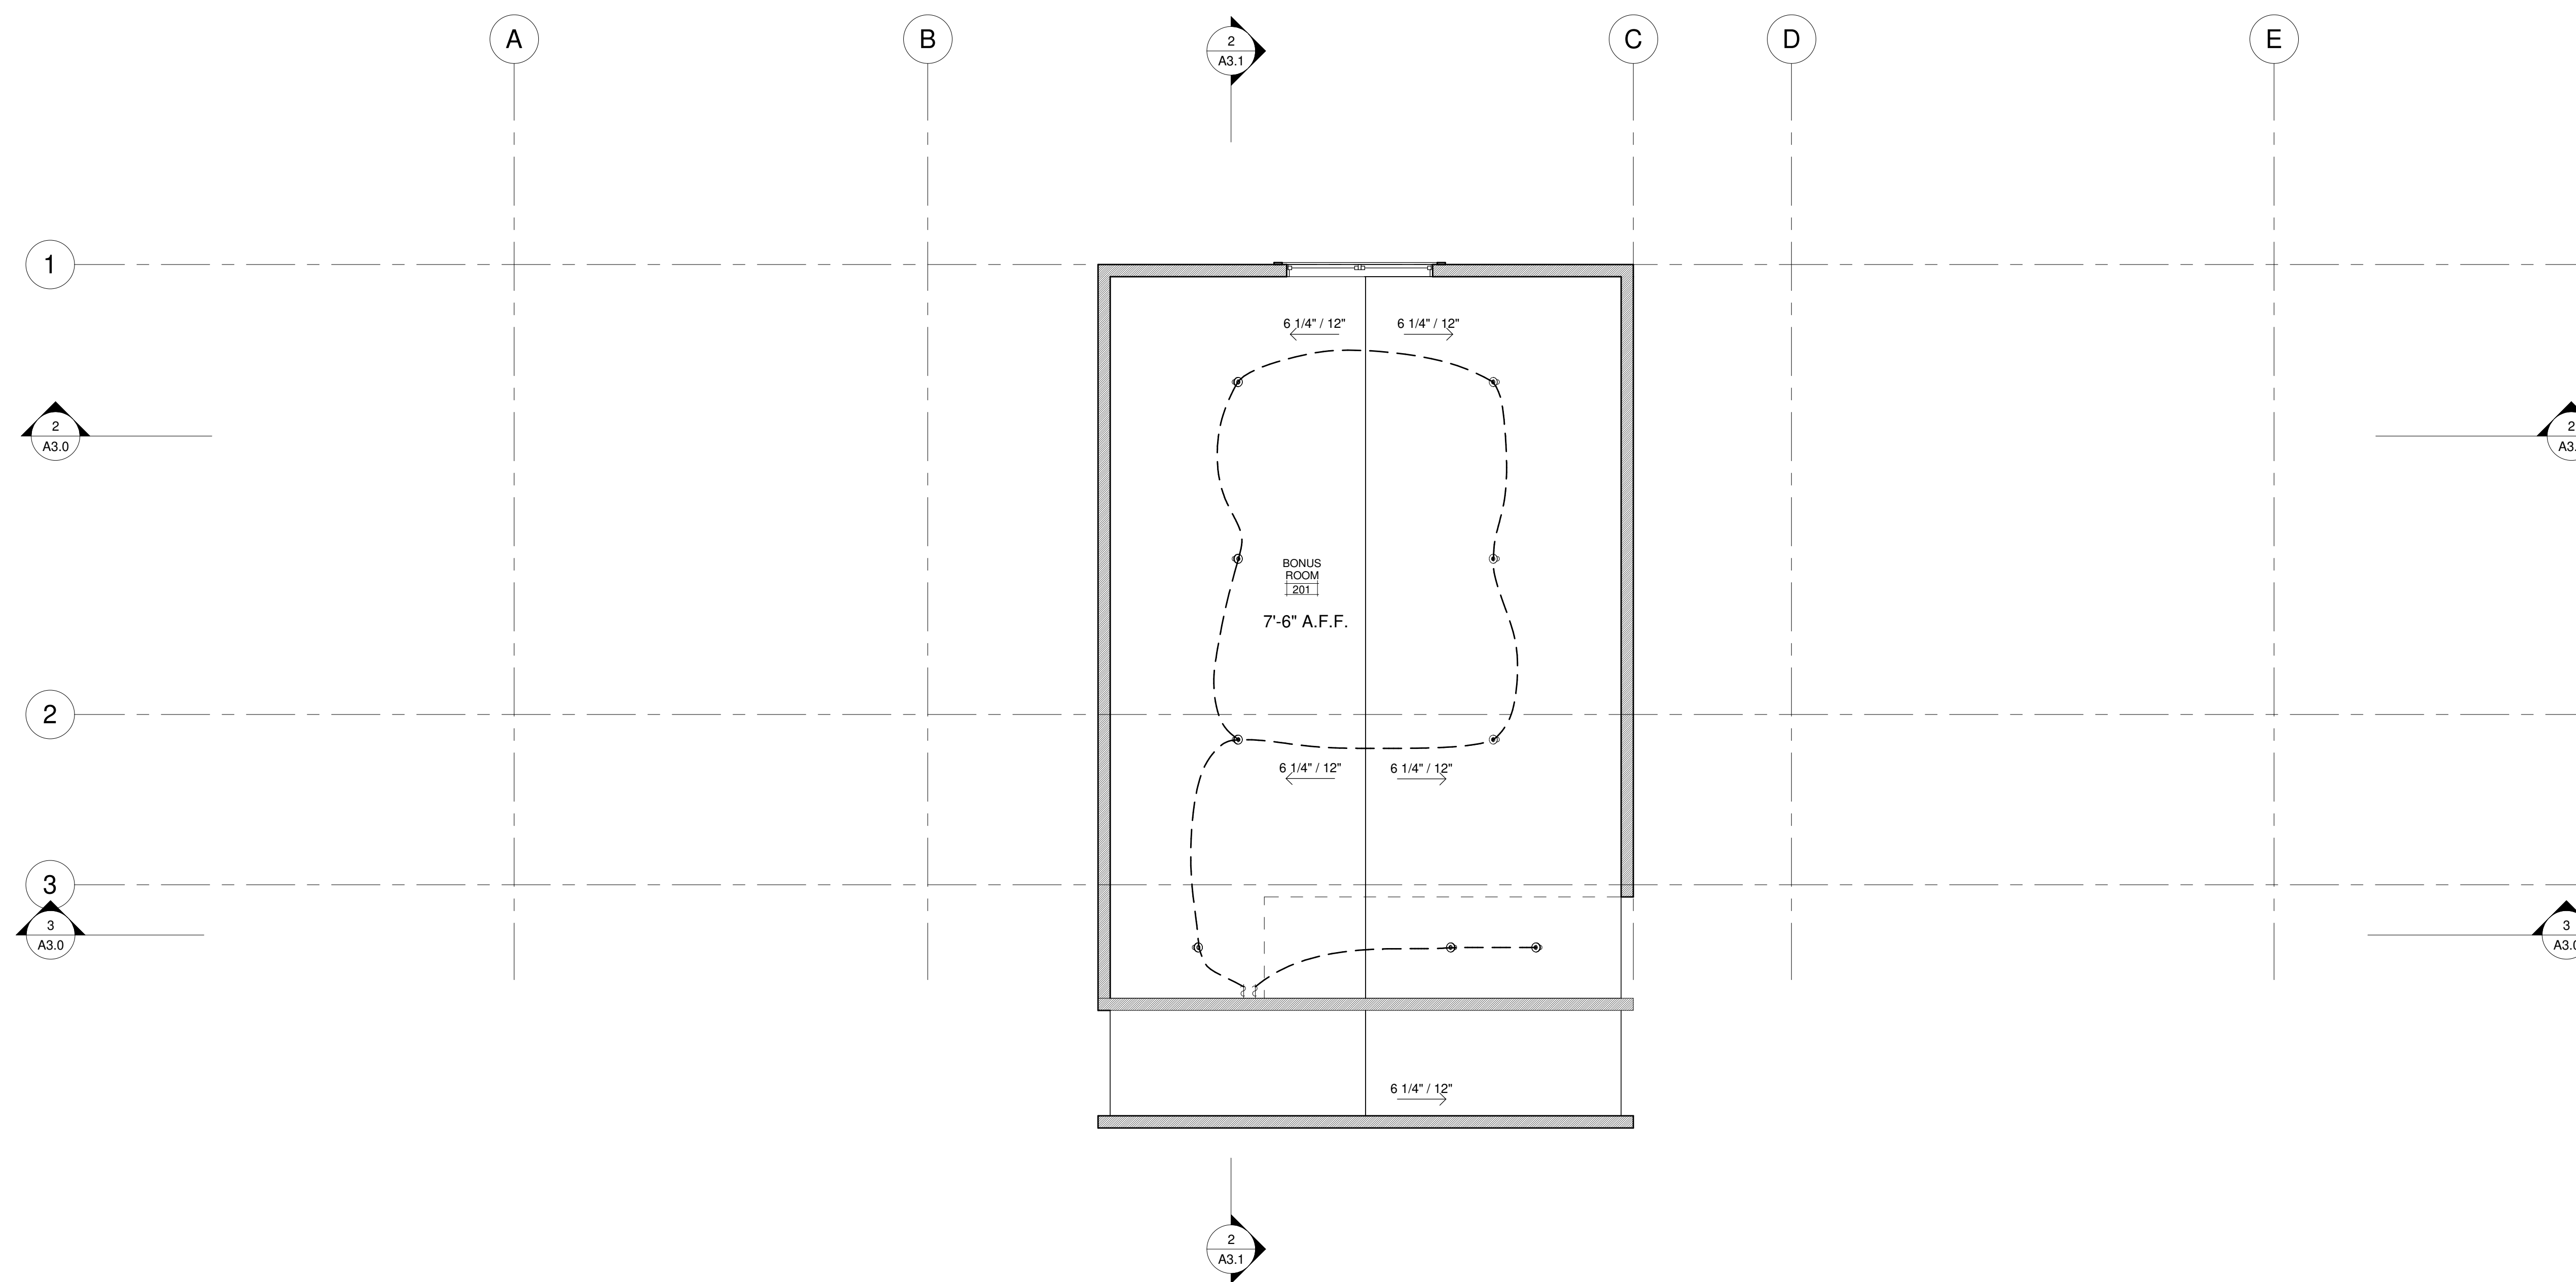

1 BONUS ROOM-LIGHTING PLAN  
1/4" = 1'-0"